


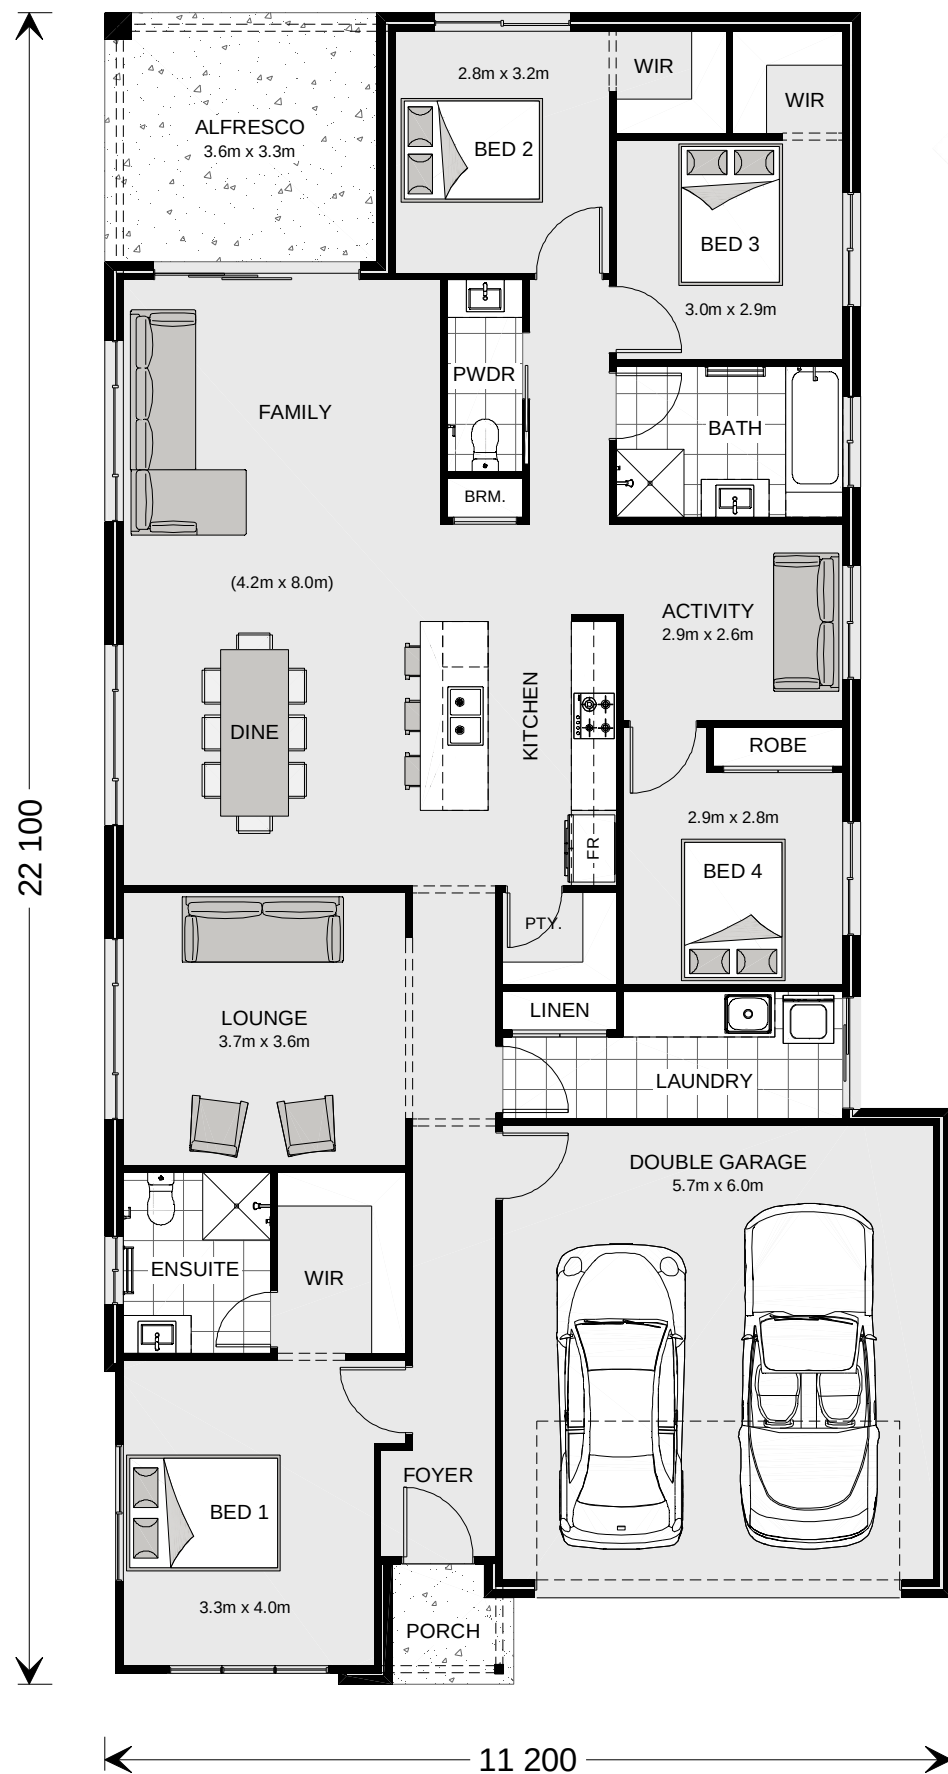


ARTISTS IMPRESSION - for illustrative purposes only
(Bridgewater 225 Beach Facade)

NCC Compatible

PLANS ARE SUBJECT TO LOCAL COUNCIL & DEVELOPERS GUIDELINES (COVENANTS).

BRIDGEWATER 225 Beach Streetscape Element Series	CONCEPT 15/03/2024	TOTAL FLOOR AREA = 222.5 m ²	Min. Lot Width 12.5 m - 14 m	PRESENTATION PLAN Scale 1:100 @A3	G.J. Gardner. HOMES
	© Copyright Archiman Pty Ltd exclusive to G.J. Gardner Homes Concept plans only, final working drawings may vary	LIVING 170.8 m ² GARAGE 37.5 m ² ALFRESCO 11.8 m ² PORCH 2.4 m ²			

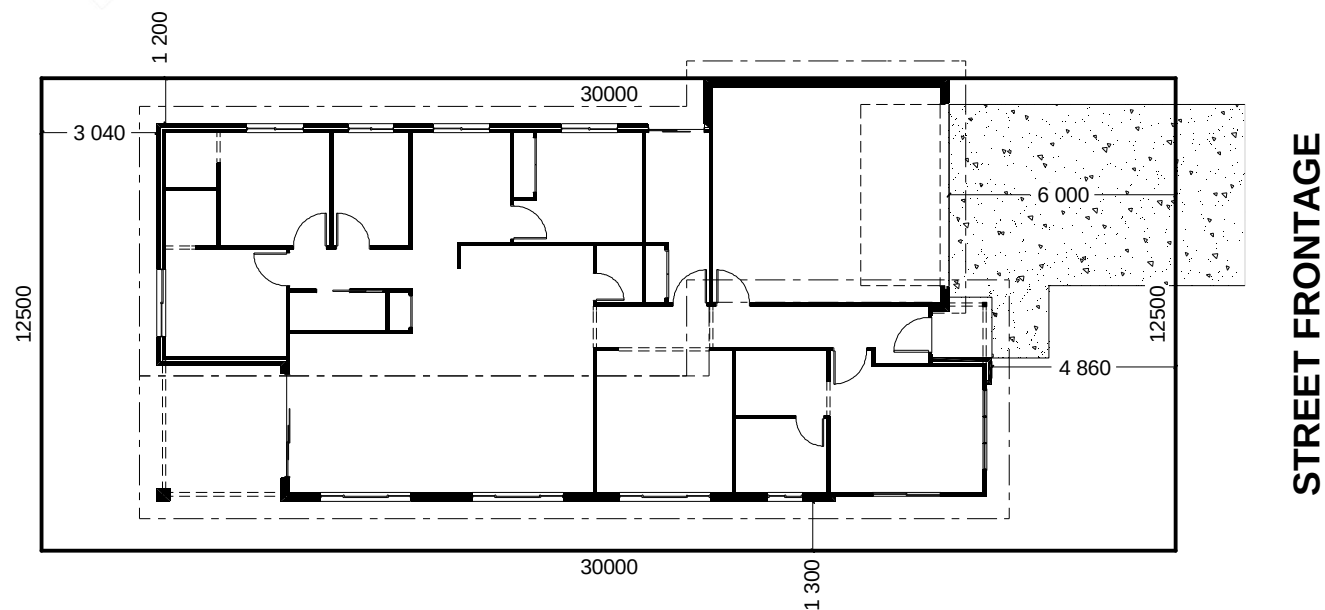

INDICATIVE SITE PLAN ONLY. ACTUAL LOT WIDTH, SIZE AND SETBACKS MAY VARY TO SUIT LOCAL REQUIREMENT'S
AND MAY REQUIRE A LARGER SITE OR PLAN MODIFICATIONS TO SUIT A PARTICULAR SITE.

NCC Compatible

PLANS ARE SUBJECT TO LOCAL COUNCIL & DEVELOPERS GUIDELINES (COVENANTS).

BRIDGEWATER 225

Beach Streetscape

Element Series

CONCEPT 15/03/2024

© Copyright Archiman Pty Ltd
exclusive to
G.J. Gardner Homes
Concept plans only,
final working drawings may vary






TOTAL FLOOR AREA = 222.5 m²

LIVING 170.8 m²
GARAGE 37.5 m²
ALFRESCO 11.8 m²
PORCH 2.4 m²





Min. Lot Width
12.5 m - 14 m

SITE PLAN
Scale 1:200 @A3

G.J. Gardner.
HOMES

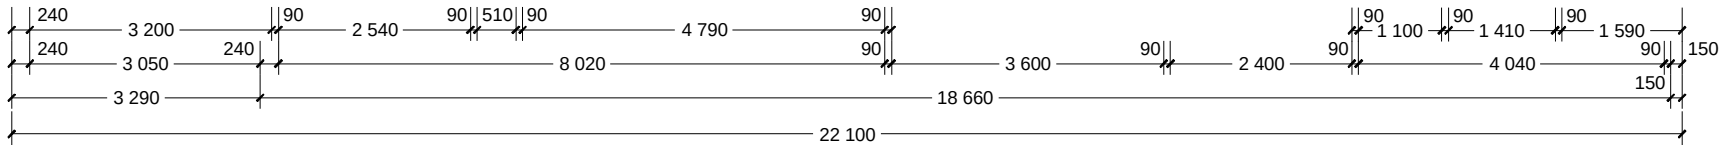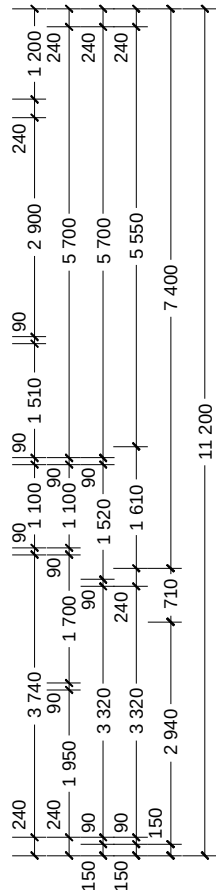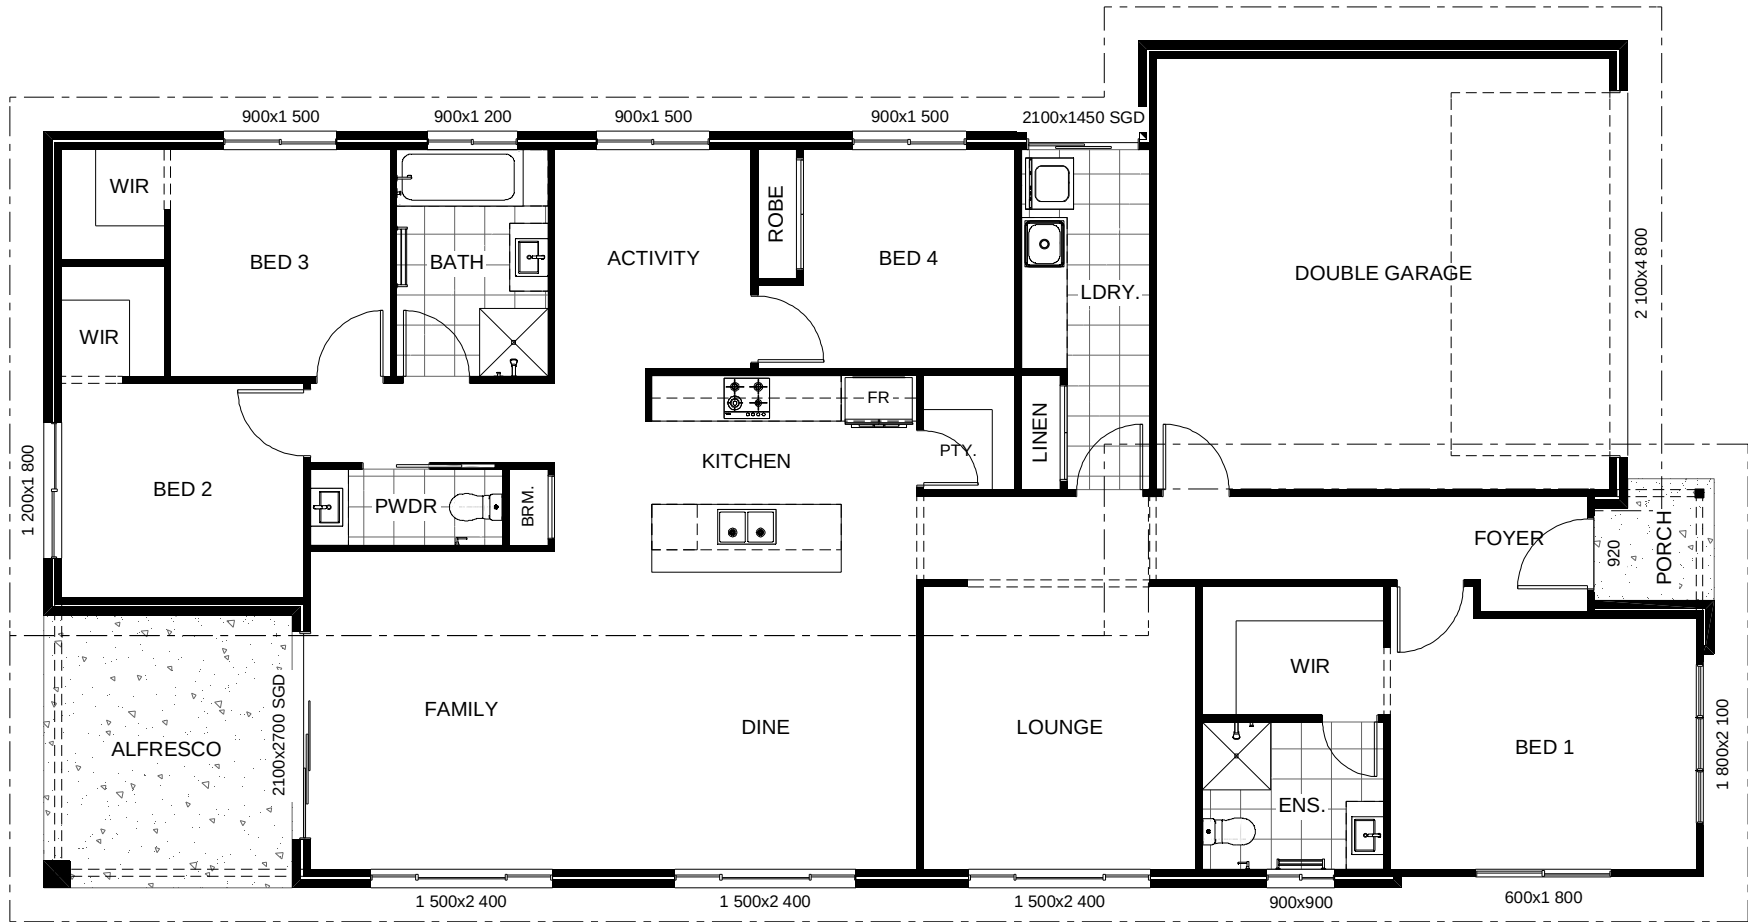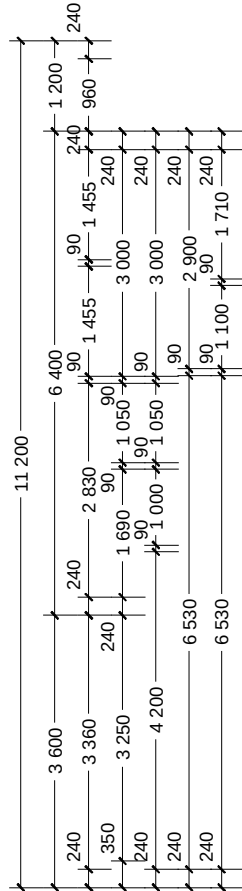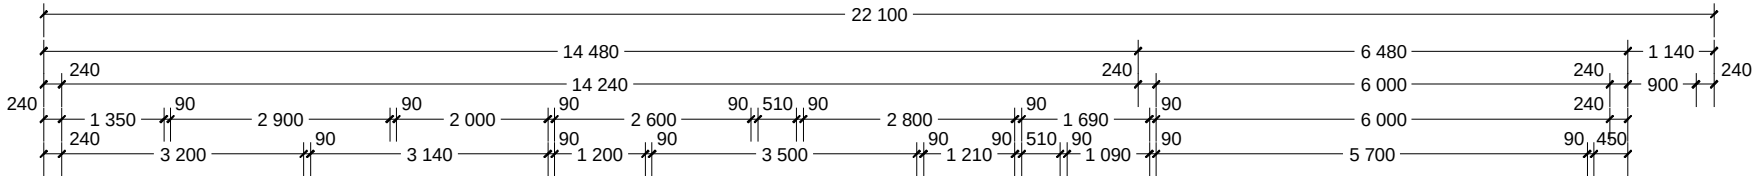

NCC Compatible		PLANS ARE SUBJECT TO LOCAL COUNCIL & DEVELOPERS GUIDELINES (COVENANTS).		
BRIDGEWATER 225 Beach Streetscape Element Series	CONCEPT 15/03/2024	TOTAL FLOOR AREA = 222.5 m ²	Min. Lot Width 12.5 m - 14 m	FLOOR PLAN Scale 1:100 @A3
	© Copyright Archiman Pty Ltd exclusive to G.J. Gardner Homes Concept plans only, final working drawings may vary	LIVING 170.8 m ² GARAGE 37.5 m ² ALFRESCO 11.8 m ² PORCH 2.4 m ²	G.J. Gardner. HOMES	

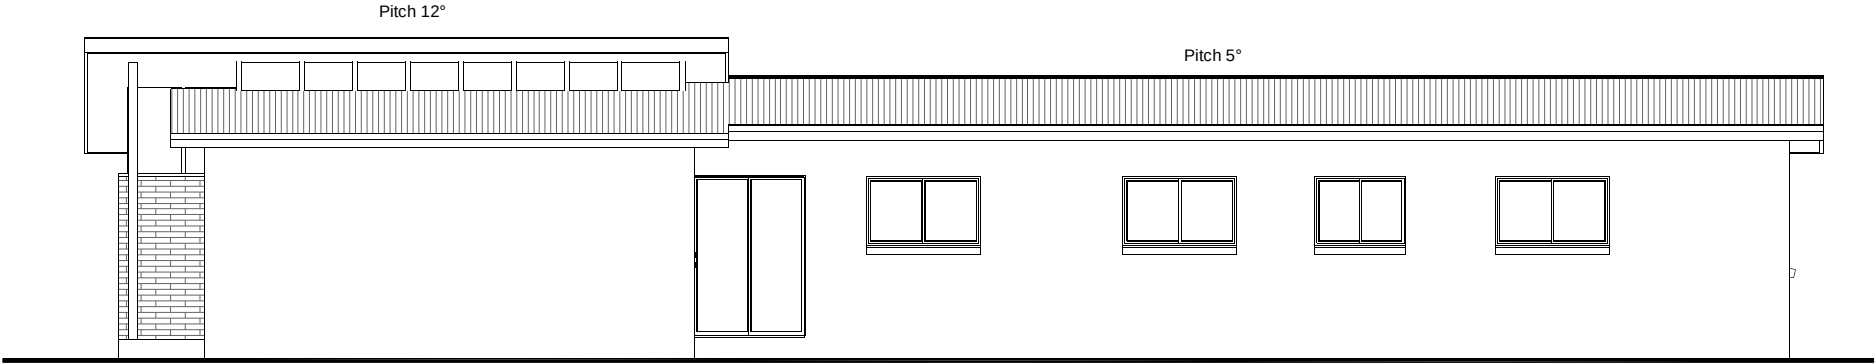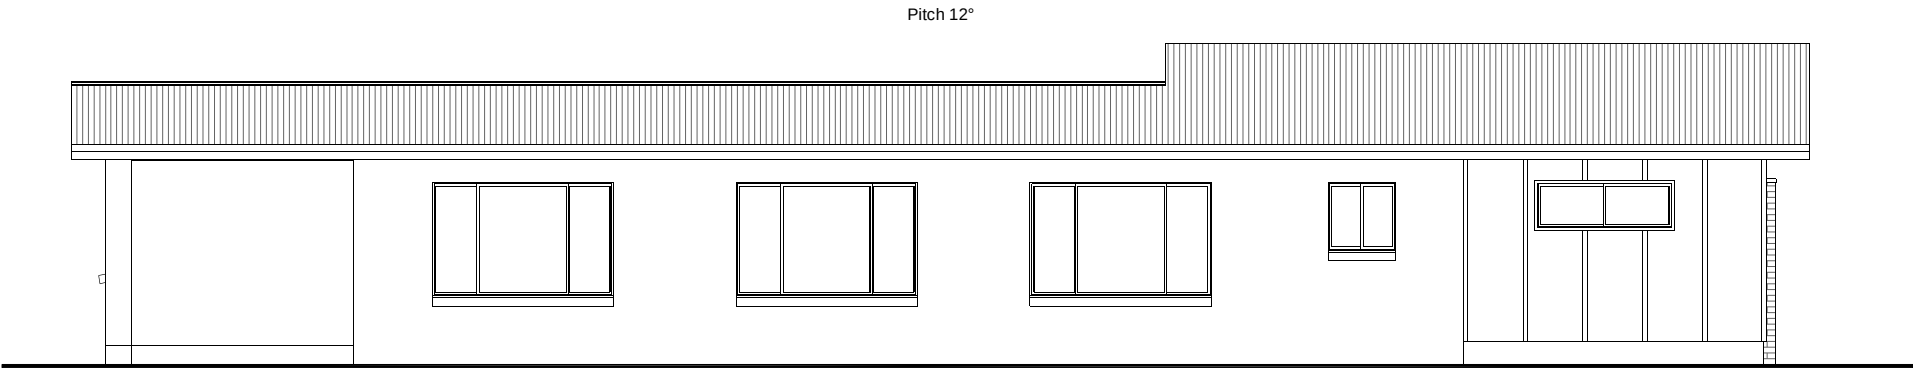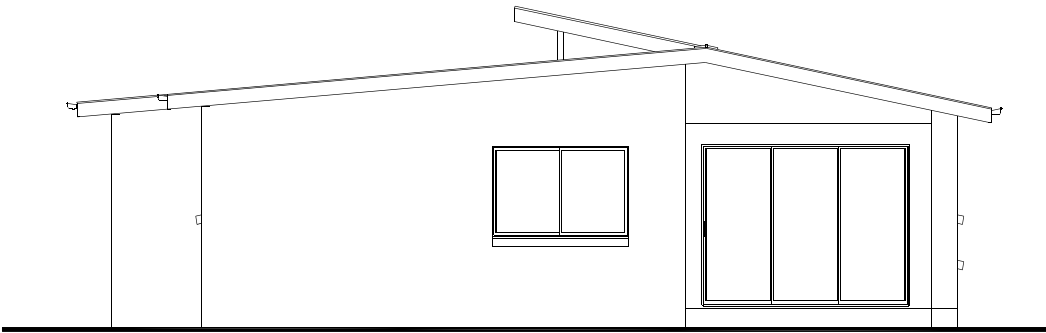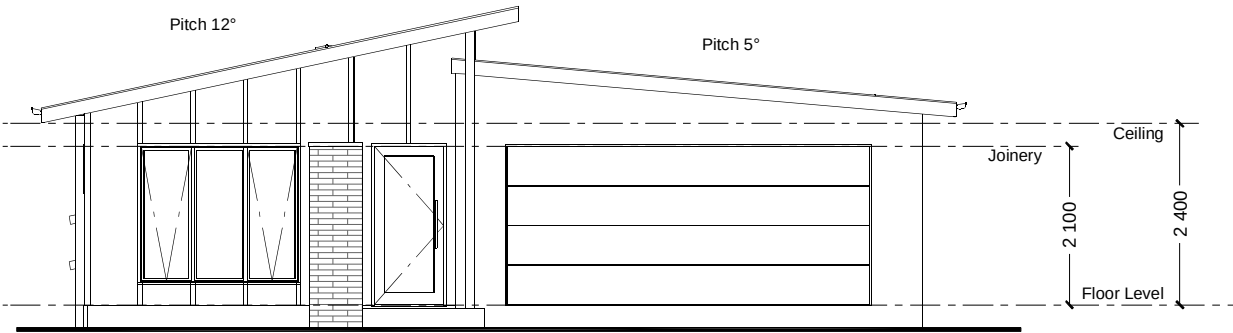

NCC Compatible

PLANS ARE SUBJECT TO LOCAL COUNCIL & DEVELOPERS GUIDELINES (COVENANTS).

BRIDGEWATER 225

Beach Streetscape

Element Series

CONCEPT 15/03/2024

TOTAL FLOOR AREA = 222.5 m²

© Copyright Archiman Pty Ltd
exclusive to
G.J. Gardner Homes
Concept plans only,
final working drawings may vary

LIVING 170.8 m²
GARAGE 37.5 m²
ALFRESCO 11.8 m²
PORCH 2.4 m²

Min. Lot Width
12.5 m - 14 m

ELEVATIONS
Scale 1:100 @A3

G.J. Gardner.

HOMES


ELECTRICAL LEGEND

NOTE:
ALL ELECTRICAL WORK MUST
BE COMPLETED TO THE
RELEVANT AUSTRALIAN
STANDARDS AND THE
NATIONAL CONSTRUCTION
CODE OF AUSTRALIA.

LIGHTING *EEF (denotes energy efficient light fittings)			
Symbol	Description	Spec.	Extra
	Ceiling Light *EEF	-	-
	Down Light *EEF	-	-
	Wall Light *EEF approx height	-	-
	Pendant / Track Light *EEF	-	-
	IXL Tastic (or similar)	-	-
	Batten Fluro Light *EEF	-	-
	Round Fluro Light *EEF	-	-
	Flood / Spot Light *EEF	-	-
TOTAL LIGHT POINTS		-	-

POWER			
	Quad Power Point	-	-
	Single Power Point	-	-
	Double Power Point	-	-
	Double W/Proof Power Point	-	-
	Single W/Proof Power Point	-	-
	T.V.Point	-	-
	Phone Point	-	-
	T.V Antenna & Booster inc. SGPO	-	-
	Dishwasher Point	-	-
	Rangehood Point	-	-
	Microwave Point	-	-
	Oven Point	-	-
	Cook Top Iso point	-	-

MISCELLANEOUS			
	Exhaust Fan	-	-
	Ceiling Fan (stainless steel)	-	-
	Ceiling Fan & Light (white) *EEF	-	-
	Meter Box	-	-
	Hot Water Service	-	-
	Smoke Detectors	-	-
	Dimmer Switch	-	-
	Two Way Switch	-	-
	A/C Condensor Iso Point	-	-

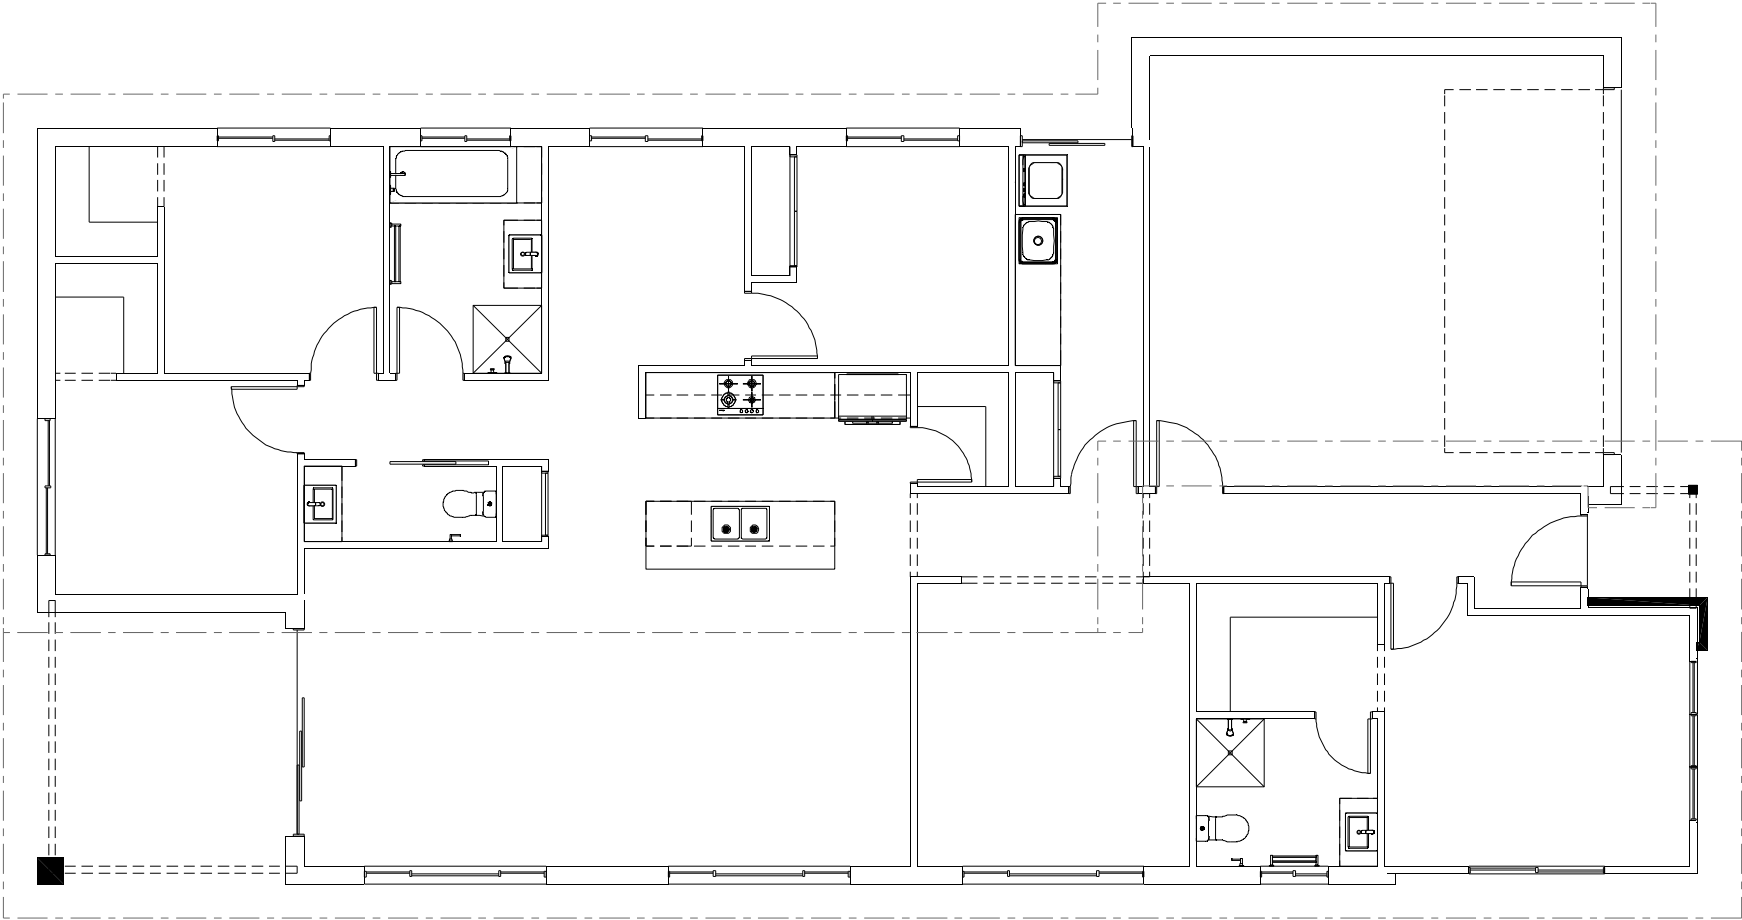

NCC Compatible

BRIDGEWATER 225

Beach Streetscape

Element Series

CONCEPT15/03/2024

© Copyright Archiman Pty Ltd exclusive to G.J. Gardner Homes
Concept plans only, final working drawings may vary

TOTAL FLOOR AREA =222.5 m²

LIVING170.8 m²
GARAGE37.5 m²
ALFRESCO11.8 m²
PORCH2.4 m²

PLANS ARE SUBJECT TO LOCAL COUNCIL & DEVELOPERS GUIDELINES (COVENANTS).

Min. Lot Width12.5 m - 14 m

ELECTRICAL PLAN
Scale 1:100 @A3

G.J. Gardner.

HOMES