

ARTISTS IMPRESSION - for illustrative purposes only
(Bridgewater 225 Hamptons Facade)

NCC Compatible

PLANS ARE SUBJECT TO LOCAL COUNCIL & DEVELOPERS GUIDELINES (COVENANTS).

BRIDGEWATER 205

Hamptons Streetscape

Element Series

CONCEPT 10/04/2025

© Copyright Archiman Pty Ltd
exclusive to
G.J. Gardner Homes
Concept plans only,
final working drawings may vary

TOTAL FLOOR AREA = 205.3 m²


LIVING	152.6 m ²
GARAGE	37.4 m ²
ALFRESCO	11.3 m ²
PORCH	4.0 m ²

Min. Lot Width
12.5 m - 14 m

PRESENTATION PLAN
Scale 1:100 @A3

G.J. Gardner.

HOMES

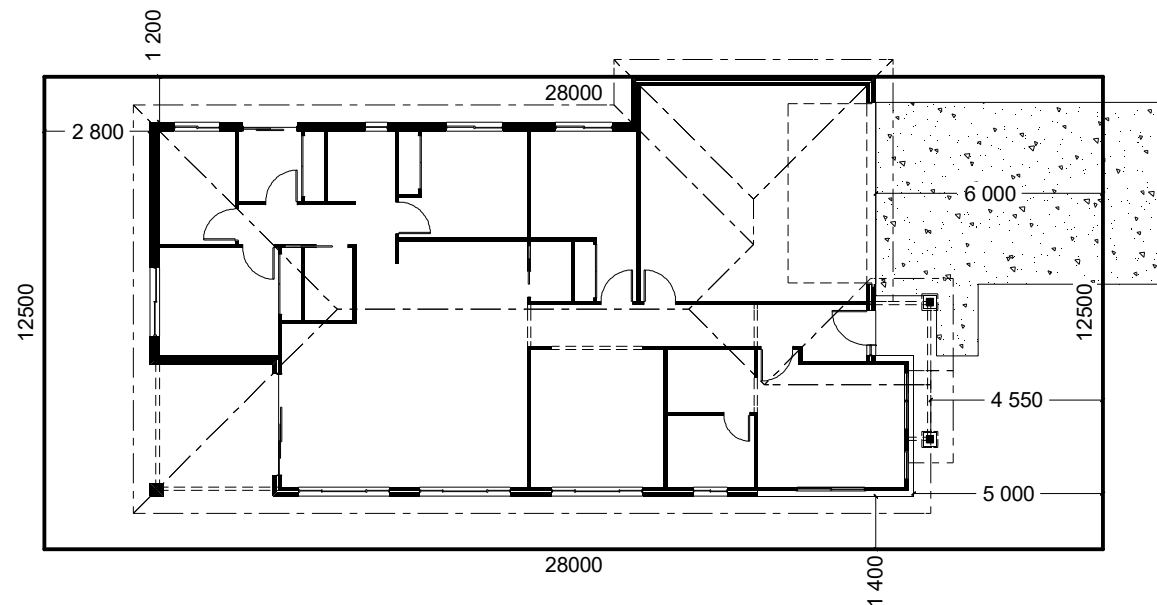

STREET FRONTAGE

INDICATIVE SITE PLAN ONLY. ACTUAL LOT WIDTH, SIZE AND SETBACKS MAY VARY TO SUIT LOCAL REQUIREMENT'S AND MAY REQUIRE A LARGER SITE OR PLAN MODIFICATIONS TO SUIT A PARTICULAR SITE.

NCC Compatible

PLANS ARE SUBJECT TO LOCAL COUNCIL & DEVELOPERS GUIDELINES (COVENANTS).

BRIDGEWATER 205

Hamptons Streetscape

Element Series

CONCEPT 10/04/2025

© Copyright Archiman Pty Ltd
exclusive to
G.J. Gardner Homes
Concept plans only,
final working drawings may vary

TOTAL FLOOR AREA = 205.3 m²






LIVING	152.6 m ²
GARAGE	37.4 m ²
ALFRESCO	11.3 m ²
PORCH	4.0 m ²

Min. Lot Width
12.5 m - 14 m

SITE PLAN
Scale 1:200 @A3

G.J. Gardner.

HOMES

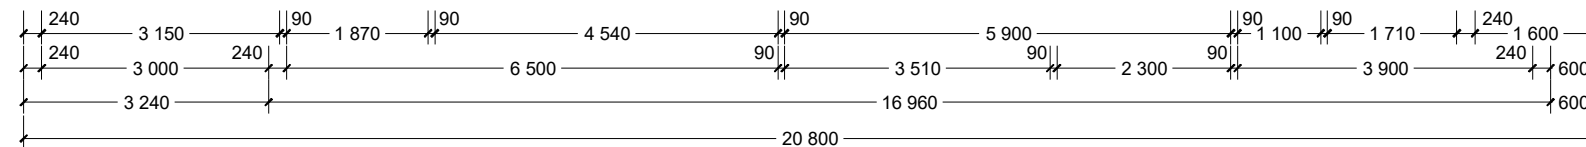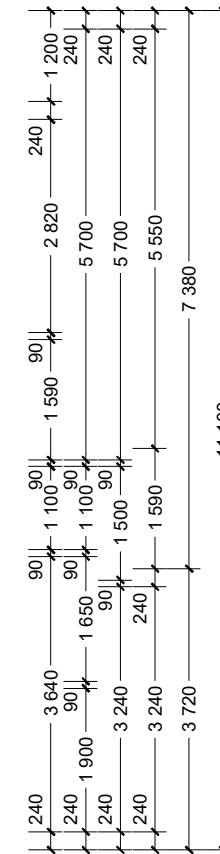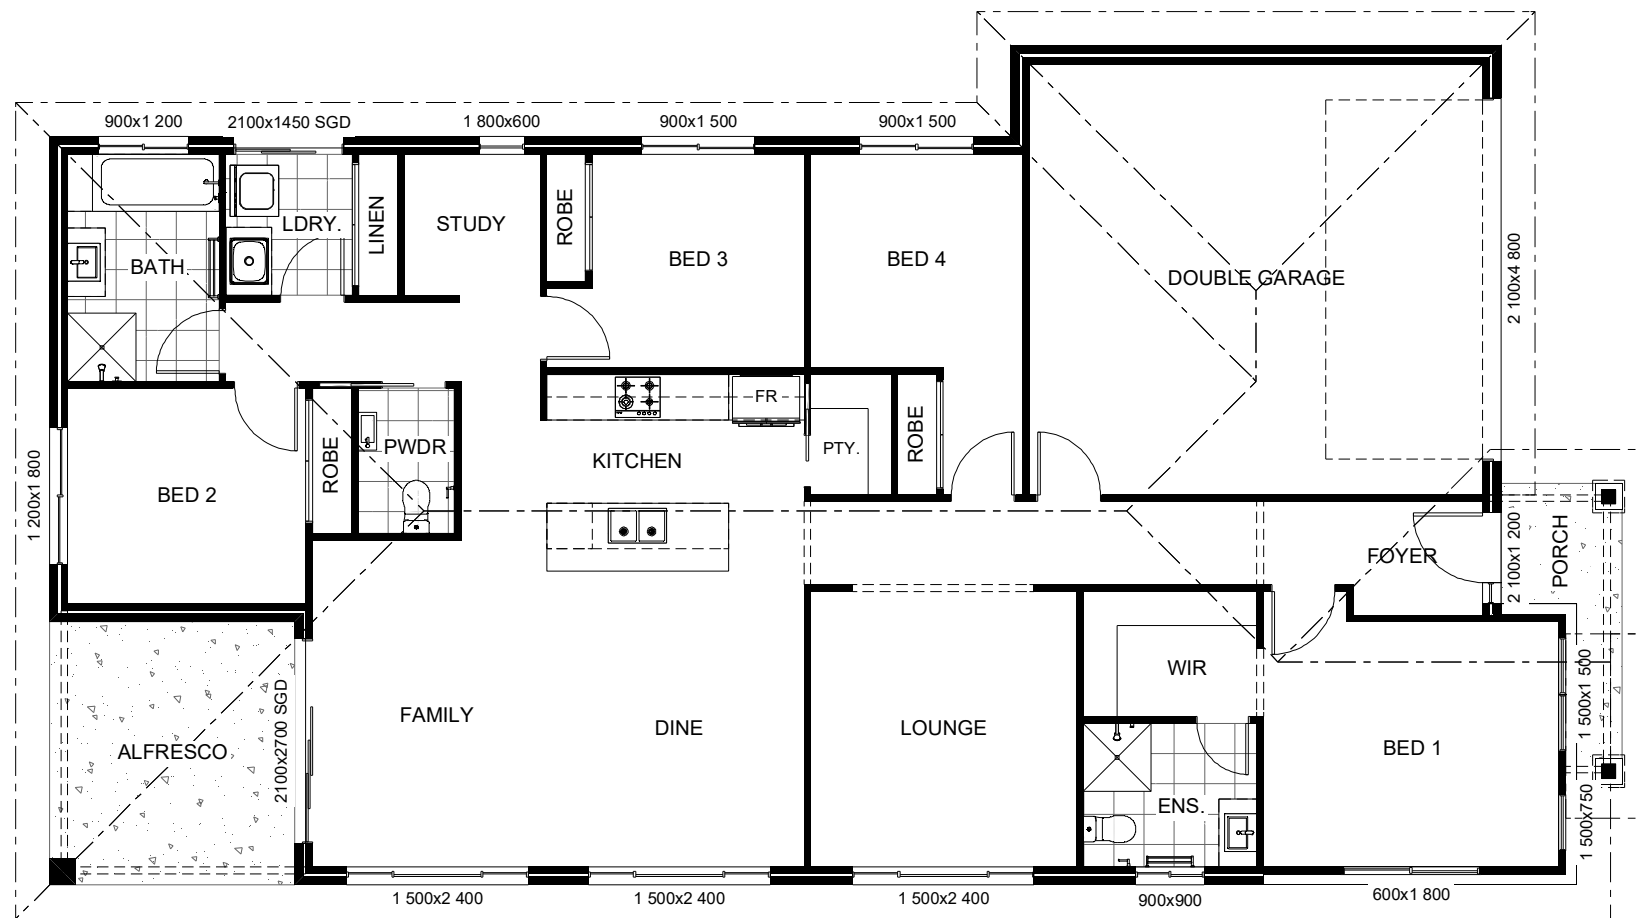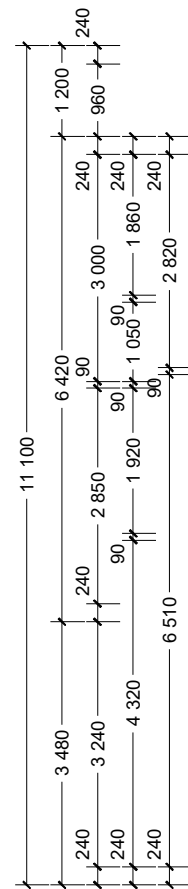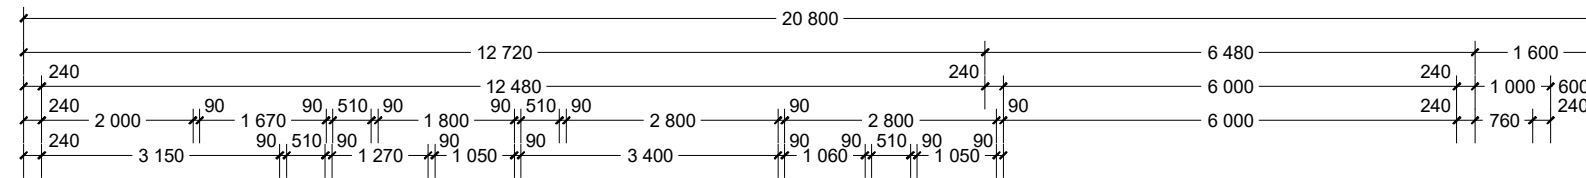

NCC Compatible

PLANS ARE SUBJECT TO LOCAL COUNCIL & DEVELOPERS GUIDELINES (COVENANTS).

BRIDGEWATER 205

Hamptons Streetscape

Element Series

CONCEPT 10/04/2025

© Copyright Archiman Pty Ltd
exclusive to
G.J. Gardner Homes
Concept plans only,
final working drawings may vary

TOTAL FLOOR AREA = 205.3 m²





LIVING 152.6 m²
GARAGE 37.4 m²
ALFRESCO 11.3 m²
PORCH 4.0 m²

Min. Lot Width
12.5 m - 14 m

FLOOR PLAN
Scale 1:100 @A3

G.J. Gardner.

HOMES

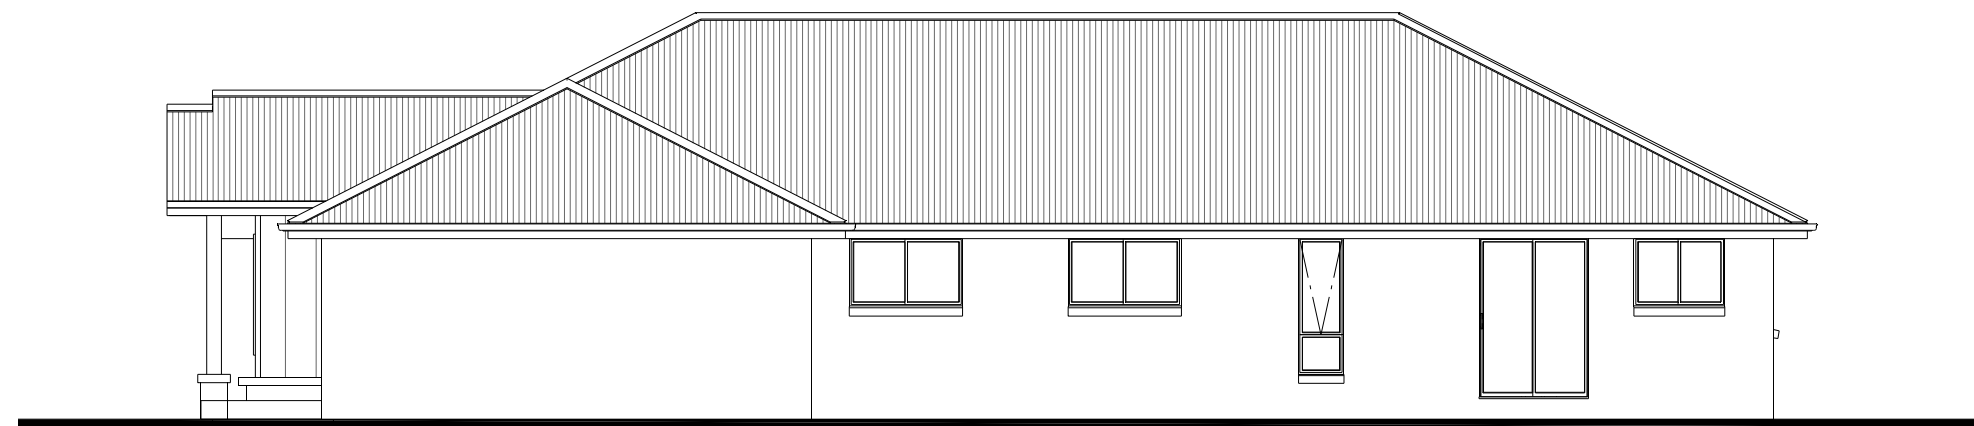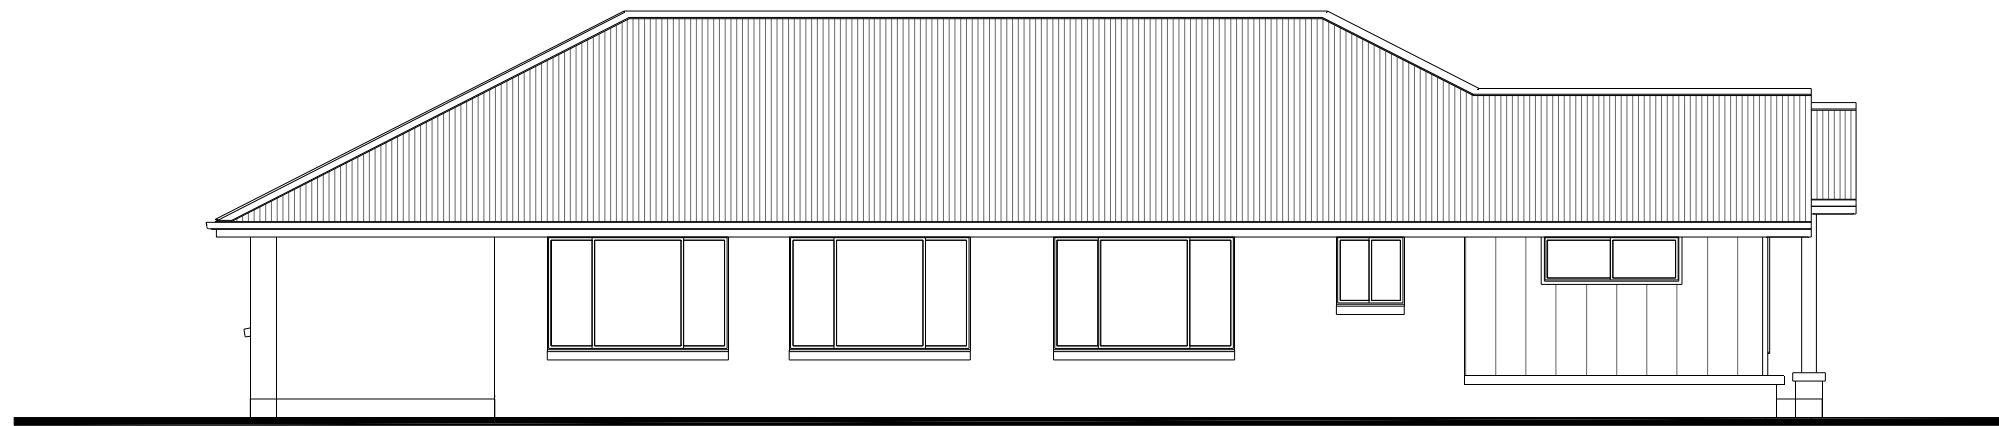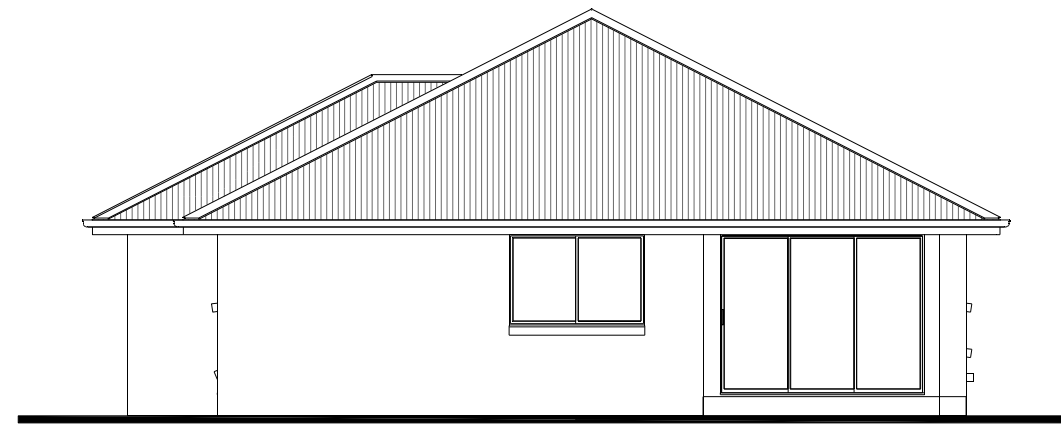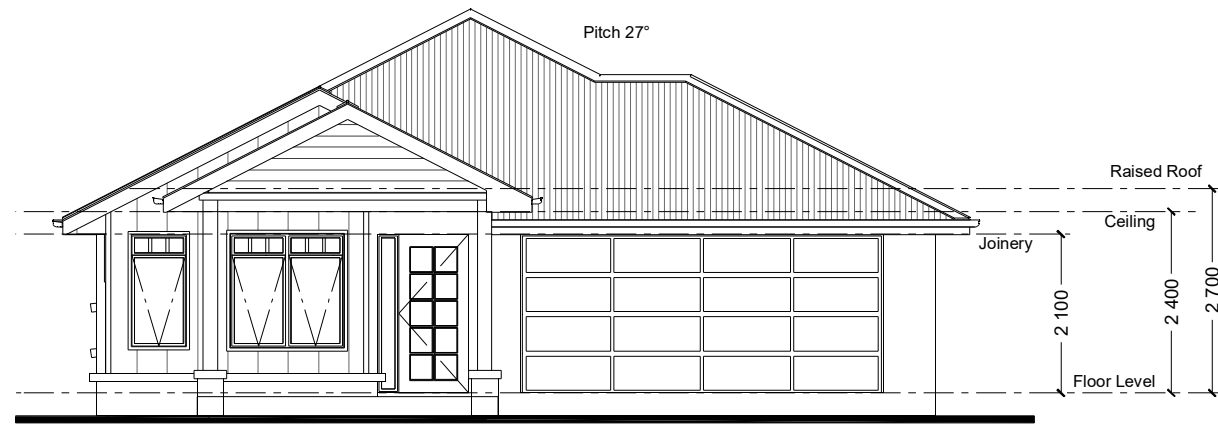

NCC Compatible

PLANS ARE SUBJECT TO LOCAL COUNCIL & DEVELOPERS GUIDELINES (COVENANTS).

BRIDGEWATER 205

Hamptons Streetscape

Element Series

CONCEPT 10/04/2025

© Copyright Archiman Pty Ltd
exclusive to
G.J. Gardner Homes
Concept plans only,
final working drawings may vary

TOTAL FLOOR AREA = 205.3 m²

LIVING	152.6 m ²
GARAGE	37.4 m ²
ALFRESCO	11.3 m ²
PORCH	4.0 m ²

Min. Lot Width
12.5 m - 14 m

ELEVATIONS
Scale 1:100 @A3

G.J. Gardner.

HOMES

ELECTRICAL LEGEND

NOTE:
ALL ELECTRICAL WORK MUST
BE COMPLETED TO THE
RELEVANT AUSTRALIAN
STANDARDS AND THE
NATIONAL CONSTRUCTION
CODE OF AUSTRALIA.

LIGHTING *EEF (denotes energy efficient light fittings)


Symbol	Description	Spec.	Extra
○	Ceiling Light *EEF	-	-
●	Down Light *EEF	-	-
⌈1800⌋	Wall Light *EEF approx height	-	-
⌈x x⌋	Pendant / Track Light *EEF	-	-
⌈xxx⌋	IXL Tastic (or similar)	-	-
⌈=⌋	Batten Fluro Light *EEF	-	-
⊙	Round Fluro Light *EEF	-	-
⌈↑⌋	Flood / Spot Light *EEF	-	-
TOTAL LIGHT POINTS		-	-

POWER

4 XXXX	Quad Power Point	-	-
1 X	Single Power Point	-	-
2 XX	Double Power Point	-	-
W/P 2 XX	Double W/Proof Power Point	-	-
W/P 1 X	Single W/Proof Power Point	-	-
T.V	T.V.Point	-	-
ph	Phone Point	-	-
⌈↑⌋	T.V Antenna & Booster inc. SGPO	-	-
D.W	Dishwasher Point	-	-
R.H	Rangehood Point	-	-
M.W	Microwave Point	-	-
O.V	Oven Point	-	-
C.T	Cook Top Iso point	-	-

MISCELLANEOUS

⌈E⌋	Exhaust Fan	-	-
⌈⊙⌋	Ceiling Fan (stainless steel)	-	-
⌈⊙⌋	Ceiling Fan & Light (white) *EEF	-	-
⌈▭⌋	Meter Box	-	-
⌈HWS⌋	Hot Water Service	-	-
⌈SA⌋	Smoke Detectors	-	-
ds	Dimmer Switch	-	-
2 way	Two Way Switch	-	-
⌈AC⌋	A/C Condensor Iso Point	-	-

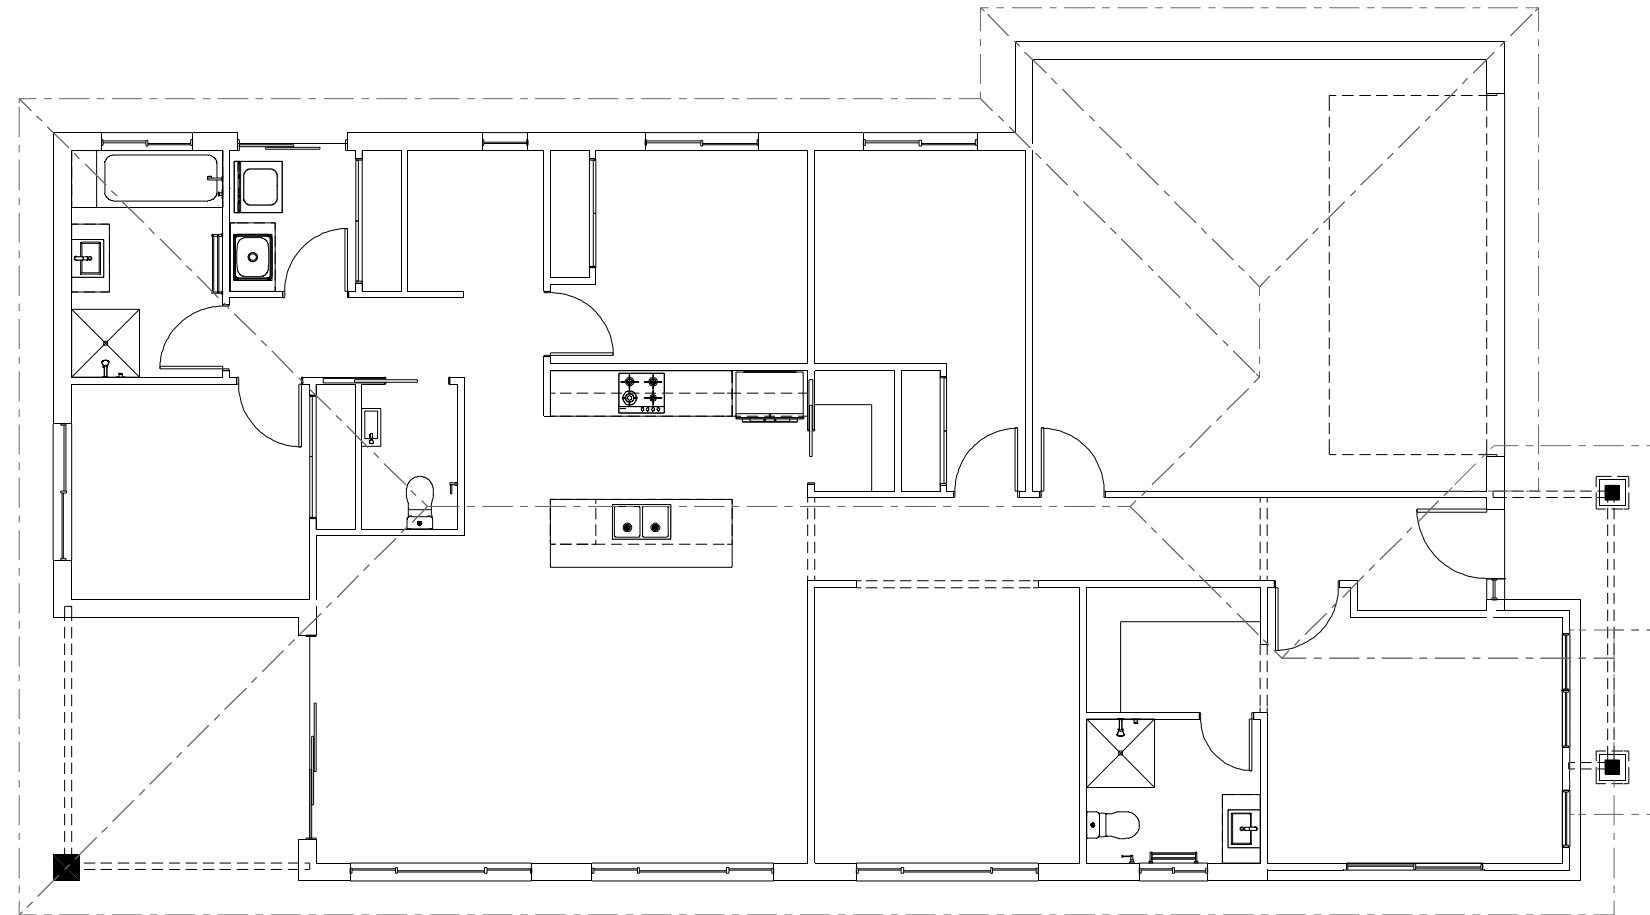

NCC Compatible

BRIDGEWATER 205

Hamptons Streetscape

Element Series

CONCEPT 10/04/2025

© Copyright Archiman Pty Ltd
exclusive to
G.J. Gardner Homes
Concept plans only,
final working drawings may vary

TOTAL FLOOR AREA = 205.3 m²

LIVING	152.6 m ²
GARAGE	37.4 m ²
ALFRESCO	11.3 m ²
PORCH	4.0 m ²

PLANS ARE SUBJECT TO LOCAL COUNCIL & DEVELOPERS GUIDELINES (COVENANTS).

Min. Lot Width
12.5 m - 14 m

ELECTRICAL PLAN
Scale 1:100 @A3

G.J. Gardner.

HOMES