



ARTISTS IMPRESSION - for illustrative purposes only
(Coolum 265 Hamptons Facade)

NCC Compatible

PLANS ARE SUBJECT TO LOCAL COUNCIL & DEVELOPERS GUIDELINES (COVENANTS).

COOLUM 225

Hamptons Streetscape
Element Series


CONCEPT 5/08/2025
© Copyright Archiman Pty Ltd
exclusive to
G.J. Gardner Homes
Concept plans only,
final working drawings may vary

TOTAL FLOOR AREA = 226.6 m²	
LIVING	173.7 m²
GARAGE	37.6 m²
ALFRESCO	9.7 m²
PORCH	5.6 m²

Min. Lot Width
14 m - 15 m

PRESENTATION PLAN
Scale 1:100 @A3

G.J. Gardner.
HOMES

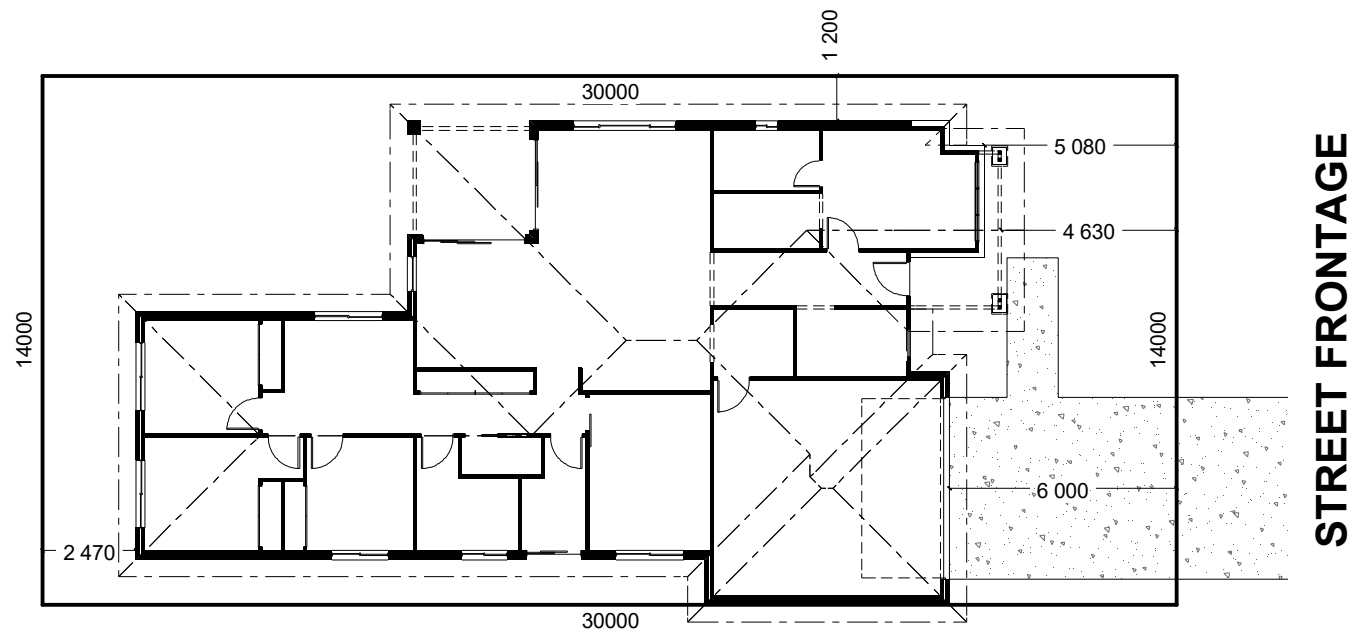

INDICATIVE SITE PLAN ONLY. ACTUAL LOT WIDTH, SIZE AND SETBACKS MAY VARY TO SUIT LOCAL REQUIREMENT'S AND MAY REQUIRE A LARGER SITE OR PLAN MODIFICATIONS TO SUIT A PARTICULAR SITE.

NCC Compatible

PLANS ARE SUBJECT TO LOCAL COUNCIL & DEVELOPERS GUIDELINES (COVENANTS).

COOLUM 225

Hamptons Streetscape

Element Series

CONCEPT5/08/2025

© Copyright Archiman Pty Ltd
exclusive to
G.J. Gardner Homes
Concept plans only,
final working drawings may vary






TOTAL FLOOR AREA = 226.6 m ²	
LIVING	173.7 m ²
GARAGE	37.6 m ²
ALFRESCO	9.7 m ²
PORCH	5.6 m ²

Min. Lot Width
14 m - 15 m

SITE PLAN
Scale 1:200 @A3

G.J. Gardner.

HOMES

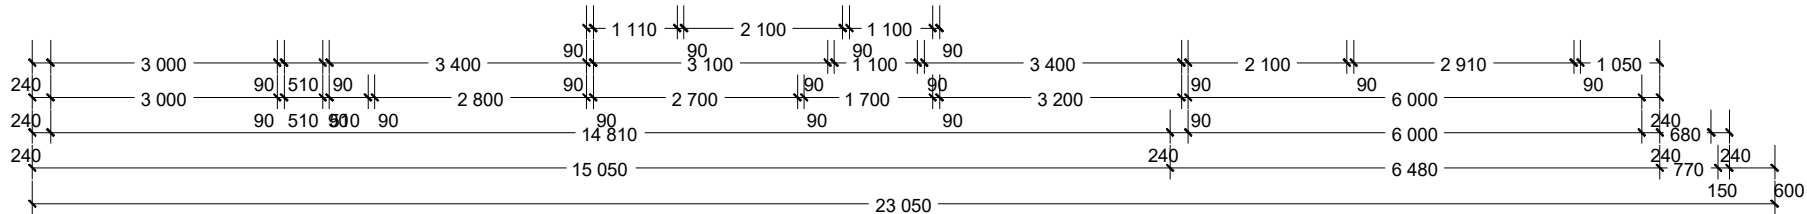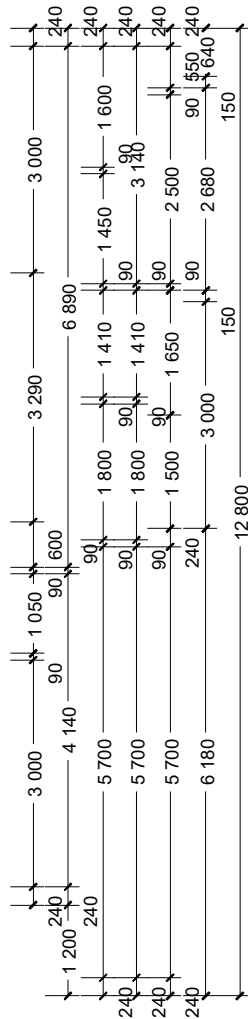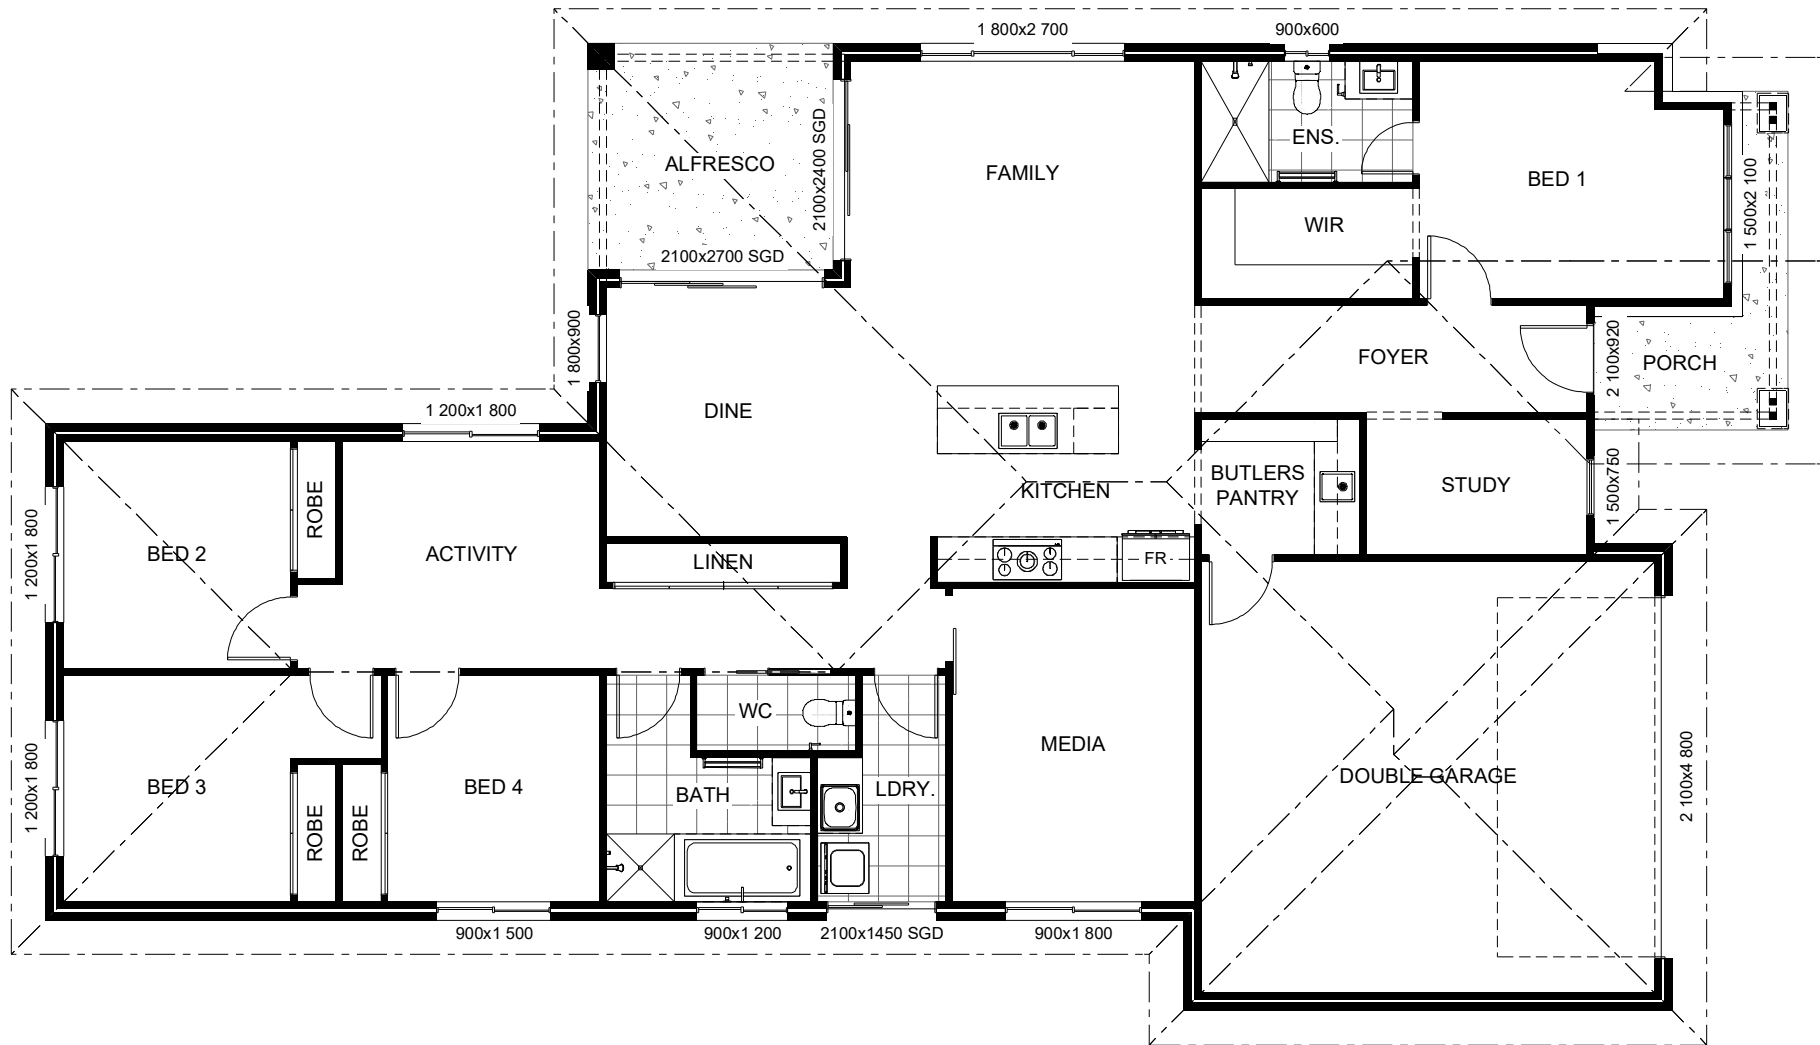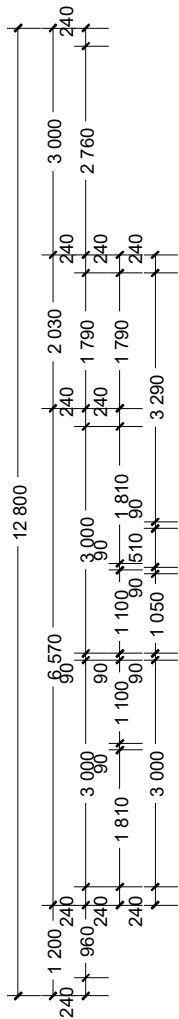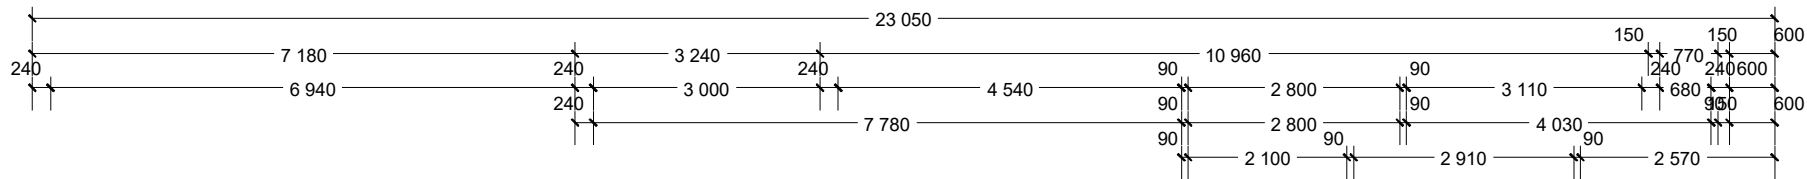

NCC Compatible		PLANS ARE SUBJECT TO LOCAL COUNCIL & DEVELOPERS GUIDELINES (COVENANTS).		
COOLUM 225 Hamptons Streetscape Element Series	CONCEPT 5/08/2025	TOTAL FLOOR AREA = 226.6 m ²	Min. Lot Width 14 m - 15 m	FLOOR PLAN Scale 1:100 @A3
	© Copyright Archiman Pty Ltd exclusive to G.J. Gardner Homes Concept plans only, final working drawings may vary	LIVING 173.7 m ² GARAGE 37.6 m ² ALFRESCO 9.7 m ² PORCH 5.6 m ²	G.J. Gardner. HOMES	



NCC Compatible

PLANS ARE SUBJECT TO LOCAL COUNCIL & DEVELOPERS GUIDELINES (COVENANTS).

COOLUM 225

Hamptons Streetscape

Element Series

CONCEPT5/08/2025

© Copyright Archiman Pty Ltd
exclusive to
G.J. Gardner Homes
Concept plans only,
final working drawings may vary

TOTAL FLOOR AREA = 226.6 m²	
LIVING	173.7 m²
GARAGE	37.6 m²
ALFRESCO	9.7 m²
PORCH	5.6 m²

Min. Lot Width

14 m - 15 m

ELEVATIONS

Scale 1:100 @A3

G.J. Gardner.

HOMES

ELECTRICAL LEGEND

NOTE:
ALL ELECTRICAL WORK MUST
BE COMPLETED TO THE
RELEVANT AUSTRALIAN
STANDARDS AND THE
NATIONAL CONSTRUCTION
CODE OF AUSTRALIA.

LIGHTING *EEF (denotes energy efficient light fittings)


Symbol	Description	Spec.	Extra
	Ceiling Light *EEF	-	-
	Down Light *EEF	-	-
	Wall Light *EEF approx height	-	-
	Pendant / Track Light *EEF	-	-
	IXL Tastic (or similar)	-	-
	Batten Fluro Light *EEF	-	-
	Round Fluro Light *EEF	-	-
	Flood / Spot Light *EEF	-	-
TOTAL LIGHT POINTS		-	-

POWER

	Quad Power Point	-	-
	Single Power Point	-	-
	Double Power Point	-	-
	Double W/Proof Power Point	-	-
	Single W/Proof Power Point	-	-
	T.V. Point	-	-
	Phone Point	-	-
	T.V Antenna & Booster inc. SGPO	-	-
	Dishwasher Point	-	-
	Rangehood Point	-	-
	Microwave Point	-	-
	Oven Point	-	-
	Cook Top Iso point	-	-

MISCELLANEOUS

	Exhaust Fan	-	-
	Ceiling Fan (stainless steel)	-	-
	Ceiling Fan & Light (white) *EEF	-	-
	Meter Box	-	-
	Hot Water Service	-	-
	Smoke Detectors	-	-
	Dimmer Switch	-	-
	Two Way Switch	-	-
	A/C Condensor Iso Point	-	-

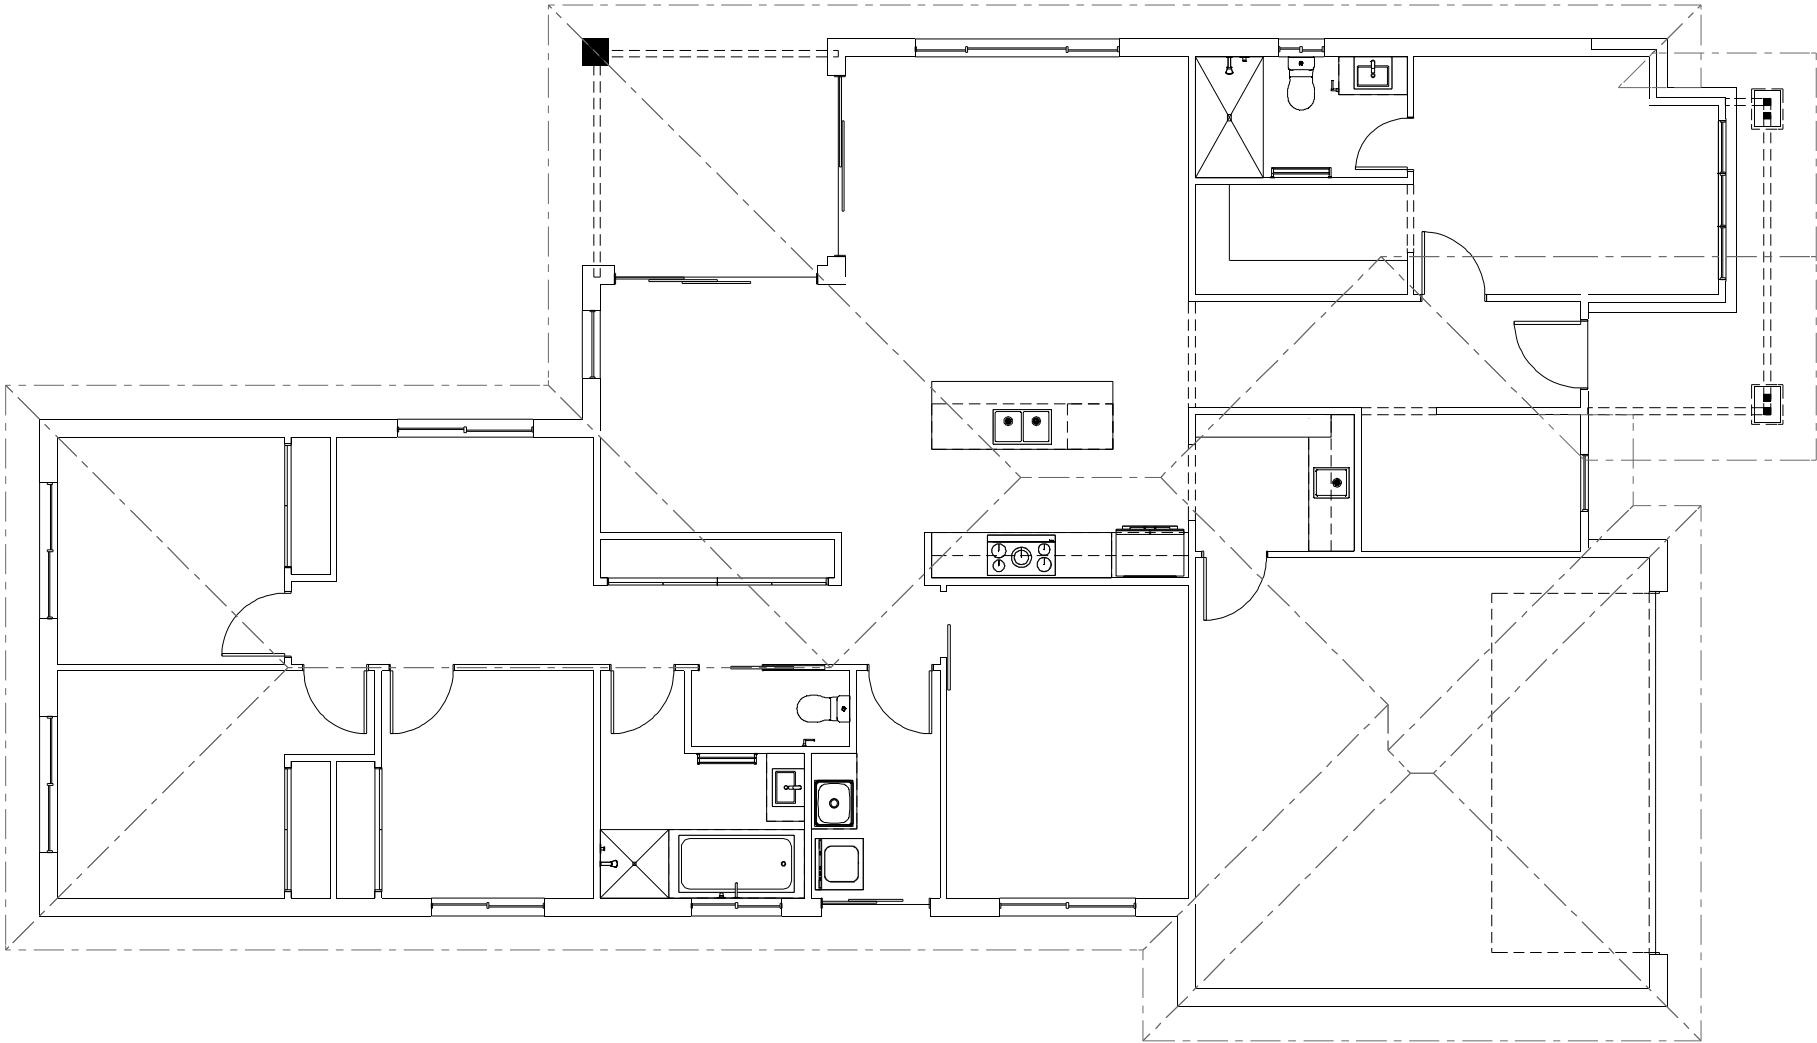

NCC Compatible

COOLUM 225

Hamptons Streetscape

Element Series

CONCEPT5/08/2025

© Copyright Archiman Pty Ltd
exclusive to
G.J. Gardner Homes
Concept plans only,
final working drawings may vary

TOTAL FLOOR AREA = 226.6 m²

LIVING173.7 m²
GARAGE37.6 m²
ALFRESCO9.7 m²
PORCH5.6 m²

PLANS ARE SUBJECT TO LOCAL COUNCIL & DEVELOPERS GUIDELINES (COVENANTS).

Min. Lot Width
14 m - 15 m

ELECTRICAL PLAN
Scale 1:100 @A3

G.J. Gardner.

HOMES