




ARTISTS IMPRESSION - for illustrative purposes only
(Mandalay 338 Hamptons Facade)

NCC Compatible		PLANS ARE SUBJECT TO LOCAL COUNCIL & DEVELOPERS GUIDELINES (COVENANTS).				
MANDALAY 280 Hamptons Streetscape Element Series	CONCEPT 18/07/2024	TOTAL FLOOR AREA = 279.8 m²		Min. Lot Width 16 m - 18 m	ARTIST IMPRESSION N.T.S.	G.J. Gardner. HOMES
	© Copyright Archiman Pty Ltd exclusive to G.J. Gardner Homes Concept plans only, final working drawings may vary	LIVING 204.6 m² GARAGE 37.1 m² ALFRESCO 24.6 m² PORCH 13.5 m²				

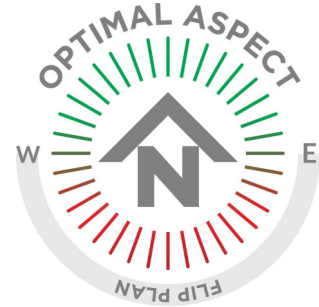

NCC Compatible

PLANS ARE SUBJECT TO LOCAL COUNCIL & DEVELOPERS GUIDELINES (COVENANTS).

MANDALAY 280

Hamptons Streetscape

Element Series

CONCEPT18/07/2024


© Copyright Archiman Pty Ltd
exclusive to
G.J. Gardner Homes
Concept plans only,
final working drawings may vary

TOTAL FLOOR AREA = 279.8 m²	
LIVING	204.6 m²
GARAGE	37.1 m²
ALFRESCO	24.6 m²
PORCH	13.5 m²

Min. Lot Width 16 m - 18 m	PRESENTATION PLAN Scale 1:100 @A3
-------------------------------	--------------------------------------

G.J. Gardner.

HOMES

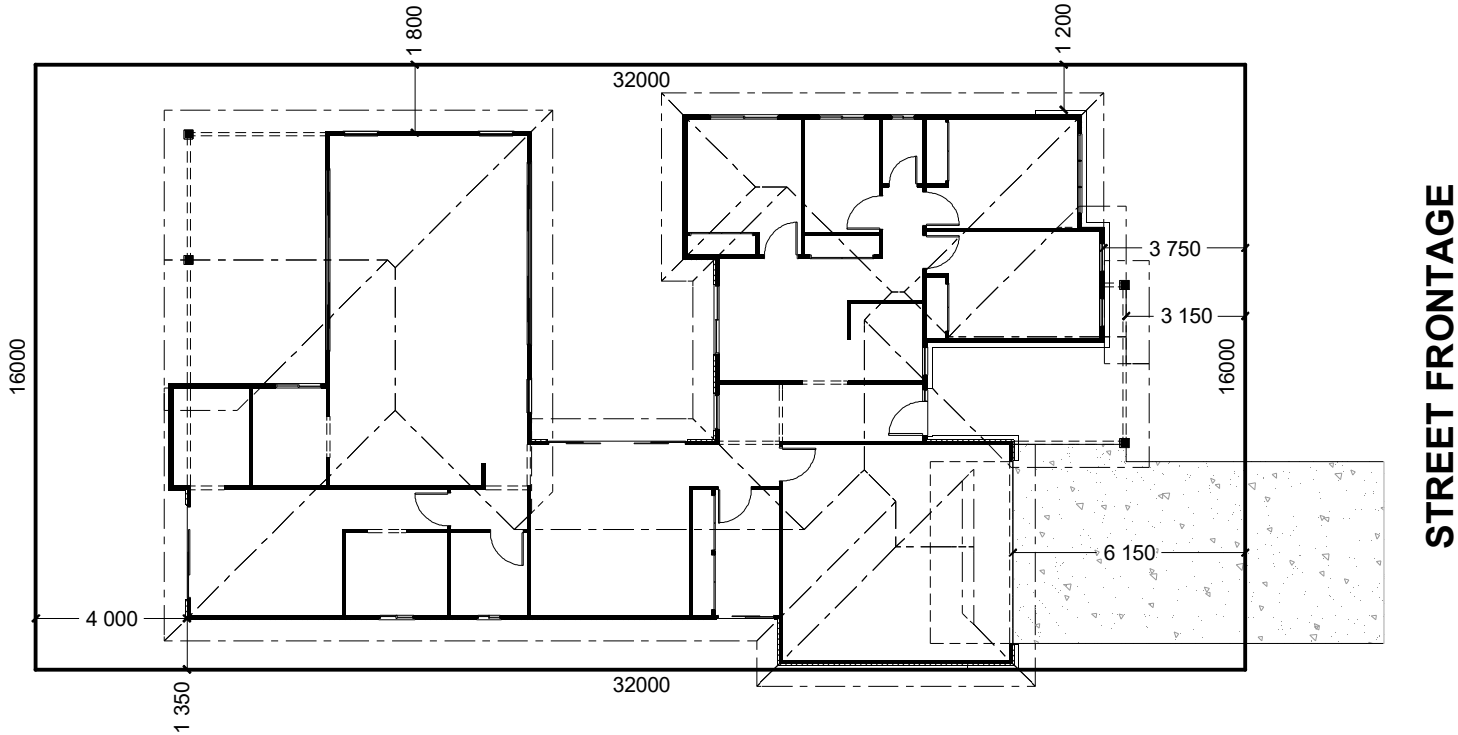

INDICATIVE SITE PLAN ONLY. ACTUAL LOT WIDTH, SIZE AND SETBACKS MAY VARY TO SUIT LOCAL REQUIREMENT'S AND MAY REQUIRE A LARGER SITE OR PLAN MODIFICATIONS TO SUIT A PARTICULAR SITE.

NCC Compatible

PLANS ARE SUBJECT TO LOCAL COUNCIL & DEVELOPERS GUIDELINES (COVENANTS).

MANDALAY 280

Hamptons Streetscape

Element Series

CONCEPT 18/07/2024
© Copyright Archiman Pty Ltd
exclusive to
G.J. Gardner Homes
Concept plans only,
final working drawings may vary

TOTAL FLOOR AREA = 279.8 m²
LIVING 204.6 m²
GARAGE 37.1 m²
ALFRESCO 24.6 m²
PORCH 13.5 m²

Min. Lot Width
16 m - 18 m

SITE PLAN
Scale 1:200 @A3

G.J. Gardner.
HOMES



NCC Compatible

PLANS ARE SUBJECT TO LOCAL COUNCIL & DEVELOPERS GUIDELINES (COVENANTS).

MANDALAY 280

Hamptons Streetscape

Element Series

CONCEPT 18/07/2024
© Copyright Archiman Pty Ltd
exclusive to
G.J. Gardner Homes
Concept plans only,
final working drawings may vary


TOTAL FLOOR AREA = 279.8 m²

LIVING 204.6 m²
GARAGE 37.1 m²
ALFRESCO 24.6 m²
PORCH 13.5 m²

Min. Lot Width
16 m - 18 m

FLOOR PLAN
Scale 1:100 @A3

G.J. Gardner.
HOMES

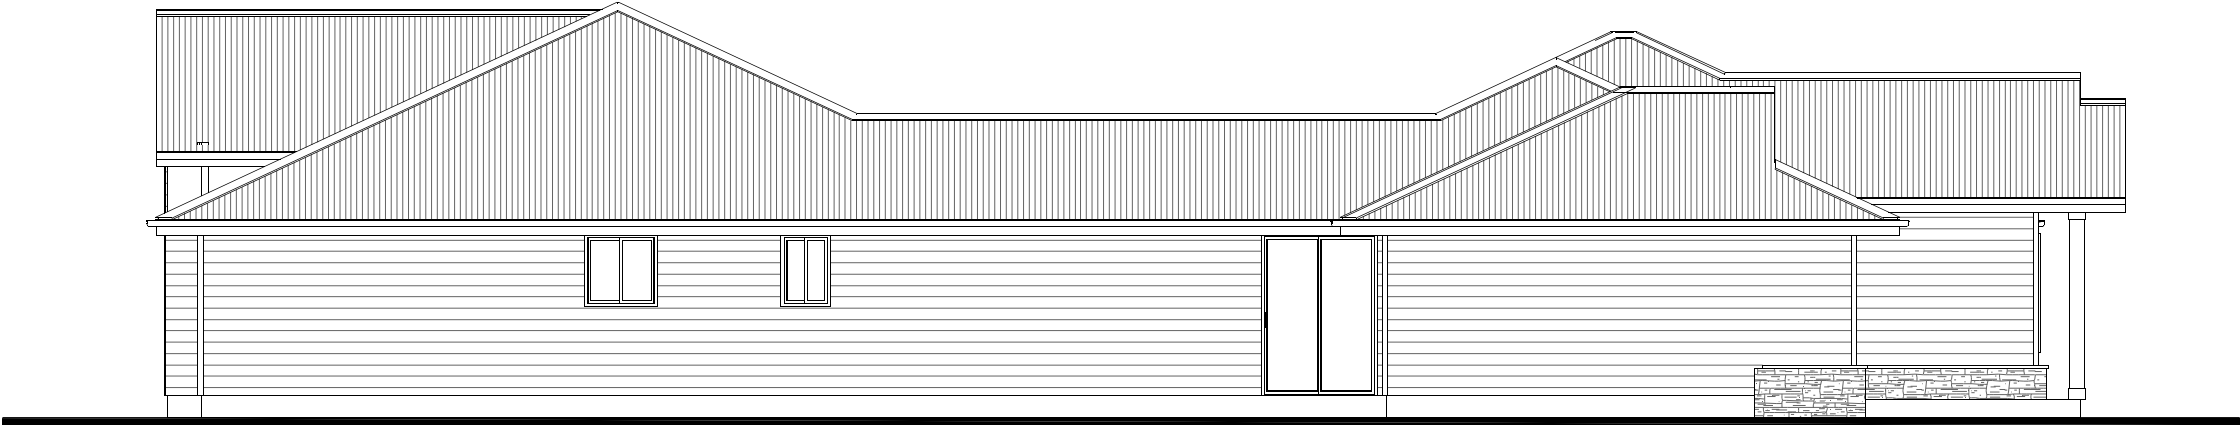

NCC Compatible

PLANS ARE SUBJECT TO LOCAL COUNCIL & DEVELOPERS GUIDELINES (COVENANTS).

MANDALAY 280

Hamptons Streetscape

Element Series

CONCEPT 18/07/2024

© Copyright Archiman Pty Ltd
exclusive to
G.J. Gardner Homes
Concept plans only,
final working drawings may vary

TOTAL FLOOR AREA = 279.8 m²


LIVING	204.6 m ²
GARAGE	37.1 m ²
ALFRESCO	24.6 m ²
PORCH	13.5 m ²

Min. Lot Width
16 m - 18 m

ELEVATIONS
Scale 1:100 @A3

G.J. Gardner.

HOMES

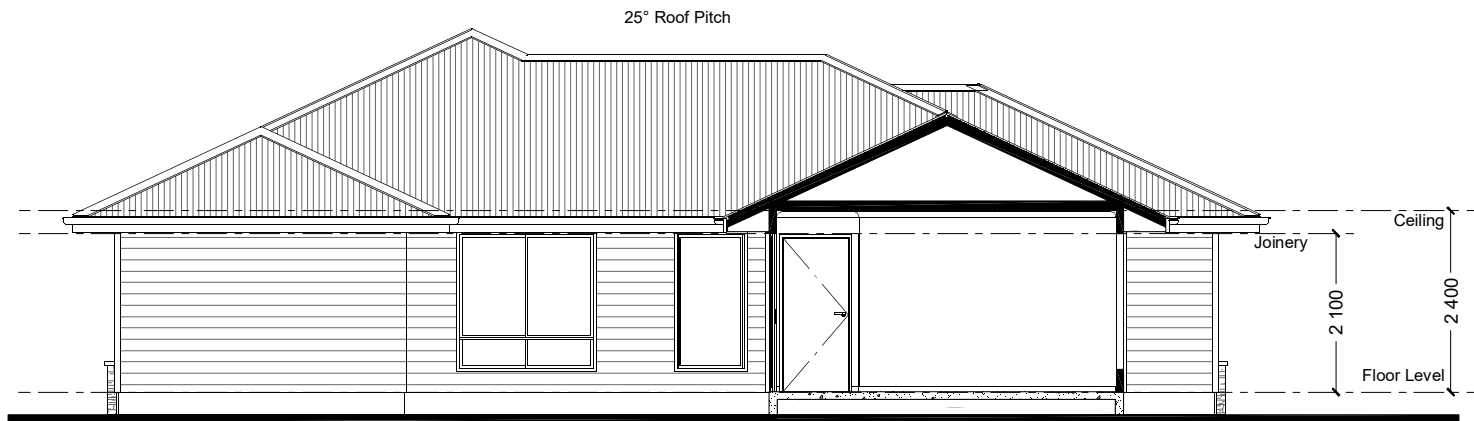

NCC Compatible

PLANS ARE SUBJECT TO LOCAL COUNCIL & DEVELOPERS GUIDELINES (COVENANTS).

MANDALAY 280

Hamptons Streetscape

Element Series

CONCEPT 18/07/2024

TOTAL FLOOR AREA = 279.8 m²

© Copyright Archiman Pty Ltd
exclusive to
G.J. Gardner Homes
Concept plans only,
final working drawings may vary

LIVING	204.6 m ²
GARAGE	37.1 m ²
ALFRESCO	24.6 m ²
PORCH	13.5 m ²

Min. Lot Width
16 m - 18 m

SECTIONS
Scale 1:100 @A3

G.J. Gardner.
HOMES

ELECTRICAL LEGEND

NOTE:
ALL ELECTRICAL WORK MUST
BE COMPLETED TO THE
RELEVANT AUSTRALIAN
STANDARDS AND THE
NATIONAL CONSTRUCTION
CODE OF AUSTRALIA.

LIGHTING *EEF (denotes energy efficient light fittings)


Symbol	Description	Spec.	Extra
	Ceiling Light *EEF	-	-
	Down Light *EEF	-	-
	Wall Light *EEF approx height	-	-
	Pendant / Track Light *EEF	-	-
	IXL Tastic (or similar)	-	-
	Batten Fluro Light *EEF	-	-
	Round Fluro Light *EEF	-	-
	Flood / Spot Light *EEF	-	-
TOTAL LIGHT POINTS		-	-

POWER

	Quad Power Point	-	-
	Single Power Point	-	-
	Double Power Point	-	-
	Double W/Proof Power Point	-	-
	Single W/Proof Power Point	-	-
	T.V. Point	-	-
	Phone Point	-	-
	T.V Antenna & Booster inc. SGPO	-	-
	Dishwasher Point	-	-
	Rangehood Point	-	-
	Microwave Point	-	-
	Oven Point	-	-
	Cook Top Iso point	-	-

MISCELLANEOUS

	Exhaust Fan	-	-
	Ceiling Fan (stainless steel)	-	-
	Ceiling Fan & Light (white) *EEF	-	-
	Meter Box	-	-
	Hot Water Service	-	-
	Smoke Detectors	-	-
	Dimmer Switch	-	-
	Two Way Switch	-	-
	A/C Condensor Iso Point	-	-

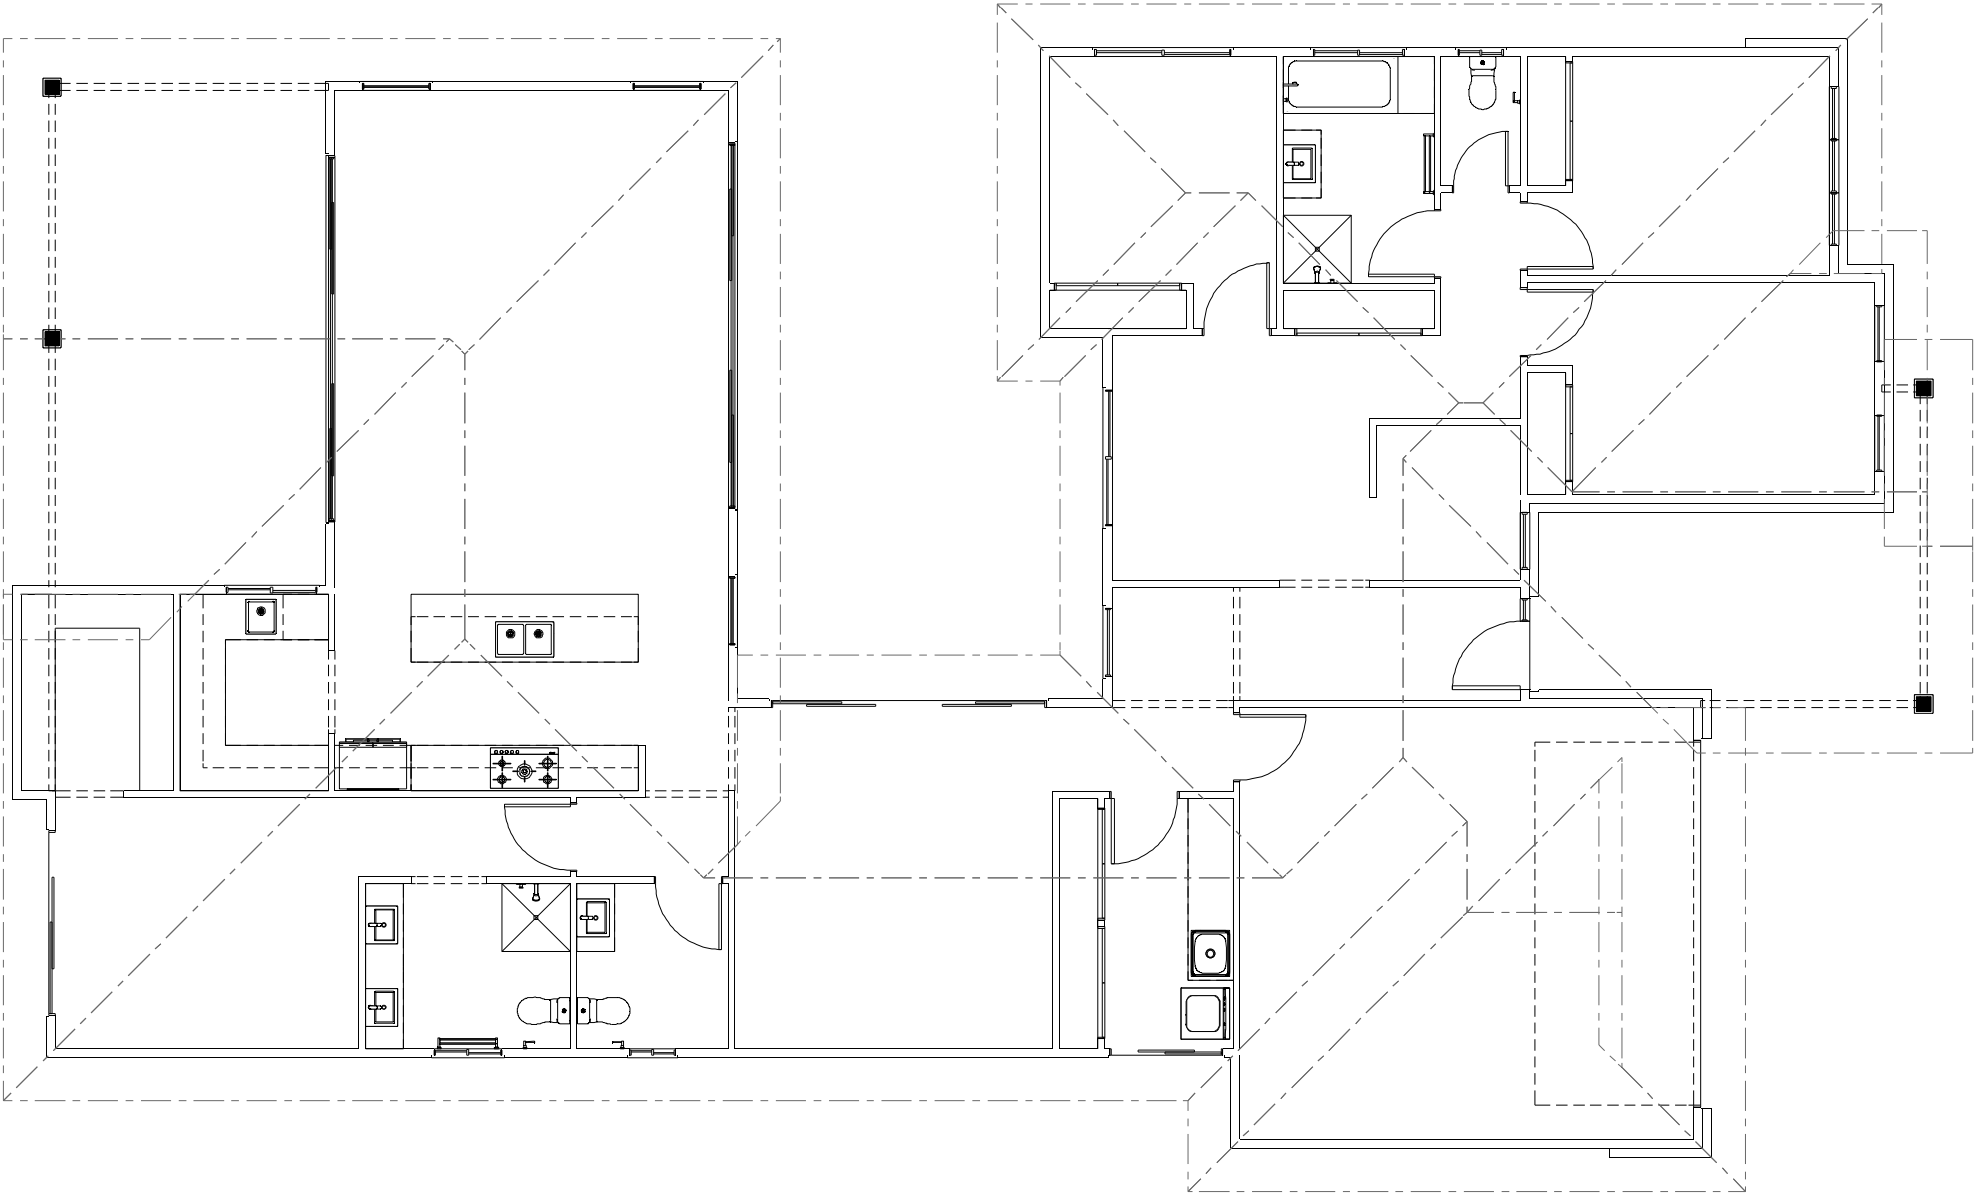

NCC Compatible

PLANS ARE SUBJECT TO LOCAL COUNCIL & DEVELOPERS GUIDELINES (COVENANTS).

MANDALAY 280

Hamptons Streetscape

Element Series

CONCEPT18/07/2024

© Copyright Archiman Pty Ltd
exclusive to
G.J. Gardner Homes
Concept plans only,
final working drawings may vary

TOTAL FLOOR AREA =279.8 m²

LIVING

GARAGE

ALFRESCO

PORCH

204.6 m²

37.1 m²

24.6 m²

13.5 m²

Min. Lot Width
16 m - 18 m

ELECTRICAL PLAN
Scale 1:100 @A3

G.J. Gardner.

HOMES