


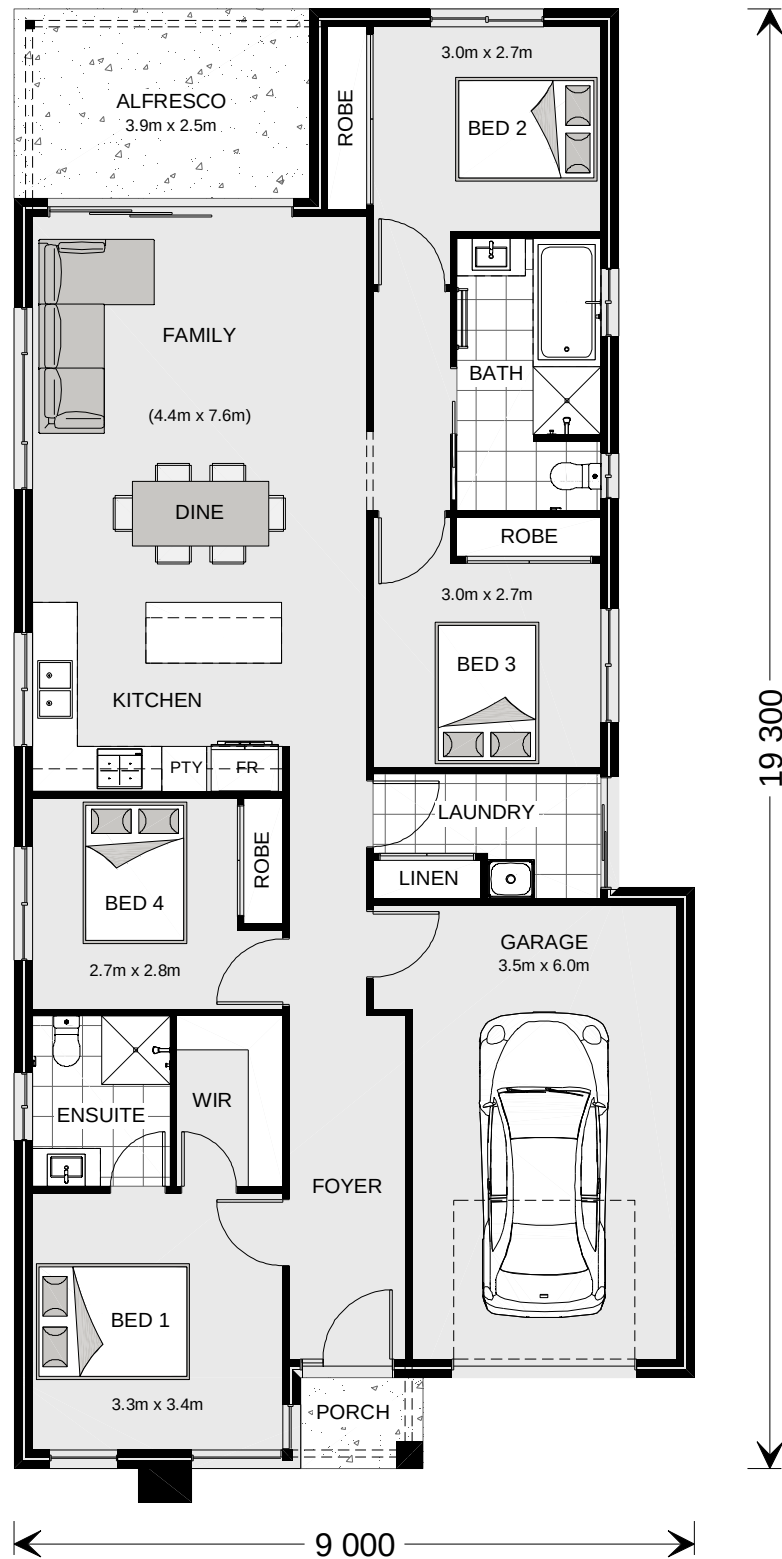


ARTISTS IMPRESSION - for illustrative purposes only

NCC Compatible

PLANS ARE SUBJECT TO LOCAL COUNCIL & DEVELOPERS GUIDELINES (COVENANTS).

CALDERWOOD 157 Executive Streetscape Metro Series	CONCEPT 17/06/2024	FLOOR AREAS	TOTAL 158.1 m ²	Min. Lot Width 10.0 m - 12.0 m	PRESENTATION PLAN Scale 1:100 @A3	G.J. Gardner. HOMES
	© Copyright Archiman Pty Ltd exclusive to G.J. Gardner Homes Concept plans only, final working drawings may vary	INTERNAL GARAGE ALFRESCO PORCH	122.2 m ² 24.2 m ² 9.8 m ² 1.9 m ²			

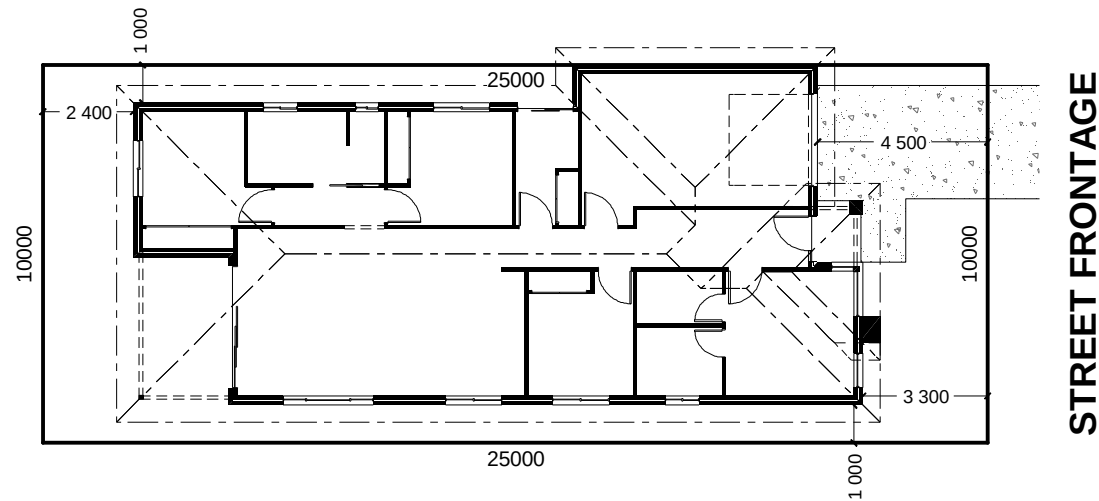

INDICATIVE SITE PLAN ONLY. ACTUAL LOT WIDTH, SIZE AND SETBACKS MAY VARY TO SUIT LOCAL REQUIREMENT'S AND MAY REQUIRE A LARGER SITE OR PLAN MODIFICATIONS TO SUIT A PARTICULAR SITE.

NCC Compatible

PLANS ARE SUBJECT TO LOCAL COUNCIL & DEVELOPERS GUIDELINES (COVENANTS).

CALDERWOOD 157

Executive Streetscape

Metro Series

CONCEPT 17/06/2024
© Copyright Archiman Pty Ltd
exclusive to
G.J. Gardner Homes
Concept plans only,
final working drawings may vary

FLOOR AREAS	TOTAL 158.1 m ²
INTERNAL	122.2 m ²
GARAGE	24.2 m ²
ALFRESCO	9.8 m ²
PORCH	1.9 m ²

Min. Lot Width
10.0 m - 12.0 m

SITE PLAN
Scale 1:200 @A3

G.J. Gardner.
HOMES

NCC Compatible

PLANS ARE SUBJECT TO LOCAL COUNCIL & DEVELOPERS GUIDELINES (COVENANTS).

CALDERWOOD 157

Executive Streetscape



Metro Series

CONCEPT 17/06/2024
© Copyright Archiman Pty Ltd
exclusive to
G.J. Gardner Homes
Concept plans only,
final working drawings may vary

FLOOR AREAS	TOTAL 158.1 m²
INTERNAL	122.2 m²
GARAGE	24.2 m²
ALFRESCO	9.8 m²
PORCH	1.9 m²

Min. Lot Width 10.0 m - 12.0 m	FLOOR PLAN Scale 1:100 @A3
-----------------------------------	-------------------------------

G.J. Gardner.
HOMES

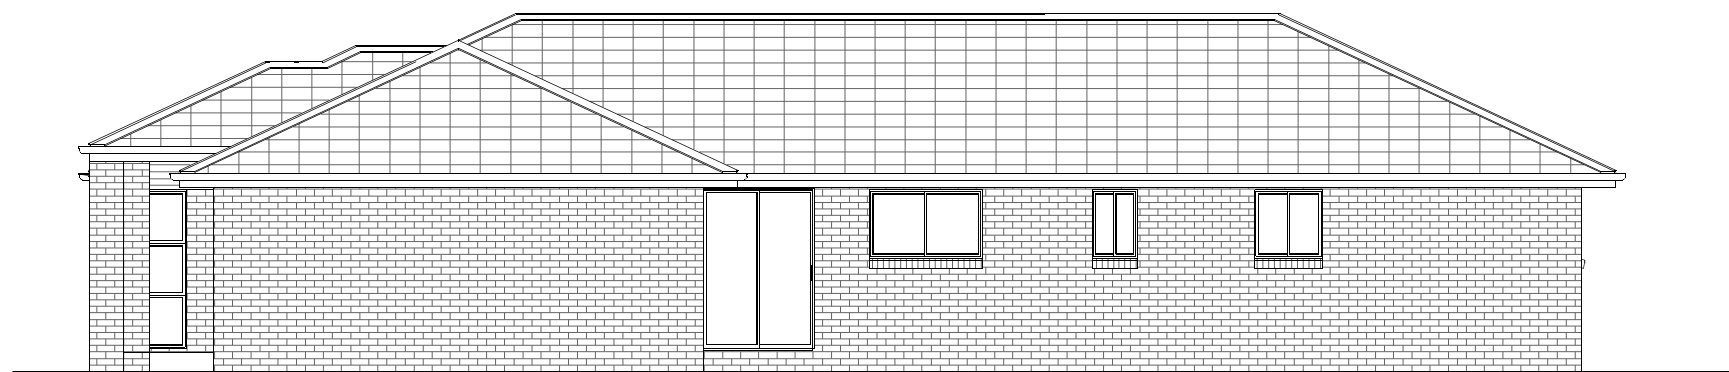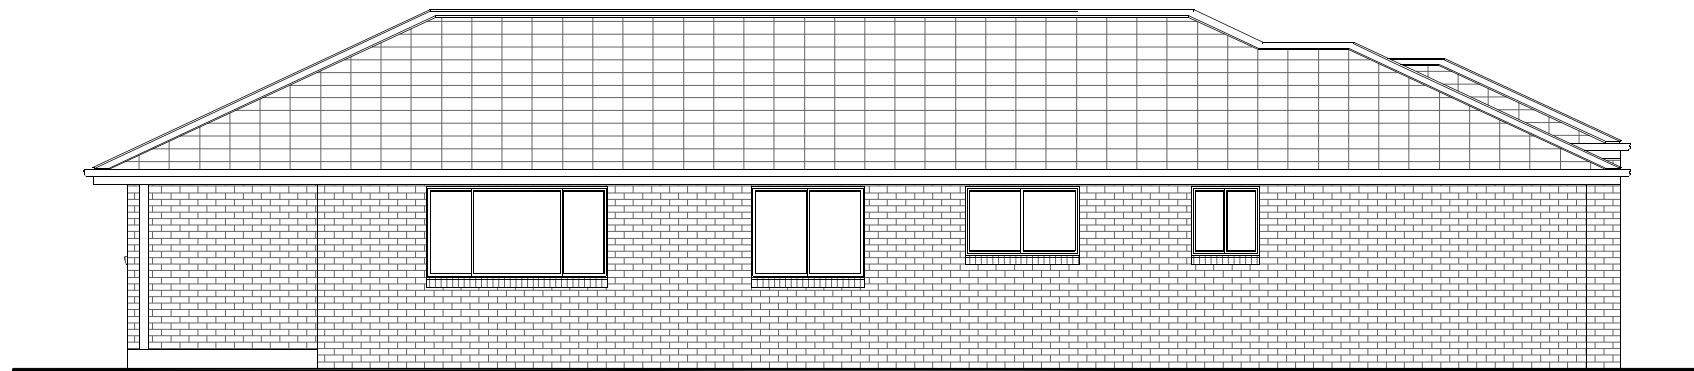

NCC Compatible		PLANS ARE SUBJECT TO LOCAL COUNCIL & DEVELOPERS GUIDELINES (COVENANTS).				G.J. Gardner. HOMES	
CALDERWOOD 157 Executive Streetscape Metro Series		CONCEPT 17/06/2024	FLOOR AREAS	TOTAL 158.1 m ²	Min. Lot Width 10.0 m - 12.0 m		
		© Copyright Archiman Pty Ltd exclusive to G.J. Gardner Homes Concept plans only, final working drawings may vary	INTERNAL GARAGE ALFRESCO PORCH	122.2 m ² 24.2 m ² 9.8 m ² 1.9 m ²	ELEVATIONS Scale 1:100 @A3		

ELECTRICAL LEGEND

NOTE:
ALL ELECTRICAL WORK MUST
BE COMPLETED TO THE
RELEVANT AUSTRALIAN
STANDARDS AND THE
NATIONAL CONSTRUCTION
CODE OF AUSTRALIA.

LIGHTING *EEF (denotes energy efficient light fittings)


Symbol	Description	Spec.	Extra
	Ceiling Light *EEF	-	-
	Down Light *EEF	-	-
	Wall Light *EEF approx height	-	-
	Pendant / Track Light *EEF	-	-
	IXL Tastic (or similar)	-	-
	Batten Fluro Light *EEF	-	-
	Round Fluro Light *EEF	-	-
	Flood / Spot Light *EEF	-	-
TOTAL LIGHT POINTS		-	-

POWER

	Quad Power Point	-	-
	Single Power Point	-	-
	Double Power Point	-	-
	Double W/Proof Power Point	-	-
	Single W/Proof Power Point	-	-
	T.V. Point	-	-
	Phone Point	-	-
	T.V Antenna & Booster inc. SGPO	-	-
	Dishwasher Point	-	-
	Rangehood Point	-	-
	Microwave Point	-	-
	Oven Point	-	-
	Cook Top Iso point	-	-

MISCELLANEOUS

	Exhaust Fan	-	-
	Ceiling Fan (stainless steel)	-	-
	Ceiling Fan & Light (white) *EEF	-	-
	Meter Box	-	-
	Hot Water Service	-	-
	Smoke Detectors	-	-
	Dimmer Switch	-	-
	Two Way Switch	-	-
	A/C Condensor Iso Point	-	-

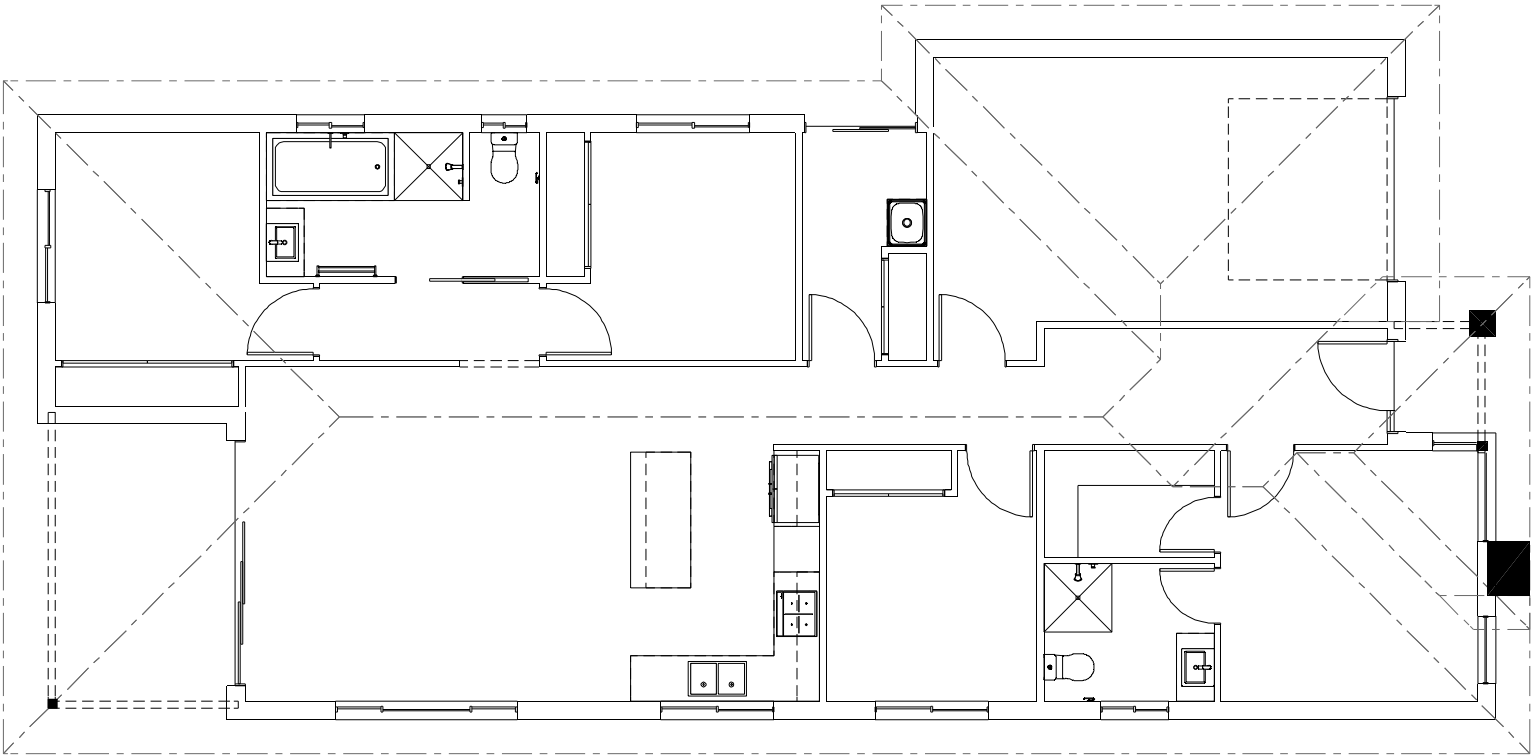

NCC Compatible

PLANS ARE SUBJECT TO LOCAL COUNCIL & DEVELOPERS GUIDELINES (COVENANTS).

CALDERWOOD 157 Executive Streetscape Metro Series	CONCEPT 17/06/2024	FLOOR AREAS	TOTAL 158.1 m²	Min. Lot Width 10.0 m - 12.0 m	ELECTRICAL PLAN Scale 1:100 @A3	G.J. Gardner. HOMES
	© Copyright Archiman Pty Ltd exclusive to G.J. Gardner Homes Concept plans only, final working drawings may vary	INTERNAL GARAGE ALFRESCO PORCH	122.2 m² 24.2 m² 9.8 m² 1.9 m²			

NCC Compatible

PLANS ARE SUBJECT TO LOCAL COUNCIL & DEVELOPERS GUIDELINES (COVENANTS).

CALDERWOOD 157

Executive Streetscape

Metro Series

CONCEPT 17/06/2024
© Copyright Archiman Pty Ltd
exclusive to
G.J. Gardner Homes
Concept plans only,
final working drawings may vary

FLOOR AREAS	TOTAL 158.1 m ²
INTERNAL	122.2 m ²
GARAGE	24.2 m ²
ALFRESCO	9.8 m ²
PORCH	1.9 m ²

Min. Lot Width
10.0 m - 12.0 m

ROOF PLAN
Scale 1:100 @A3

G.J. Gardner.
HOMES