


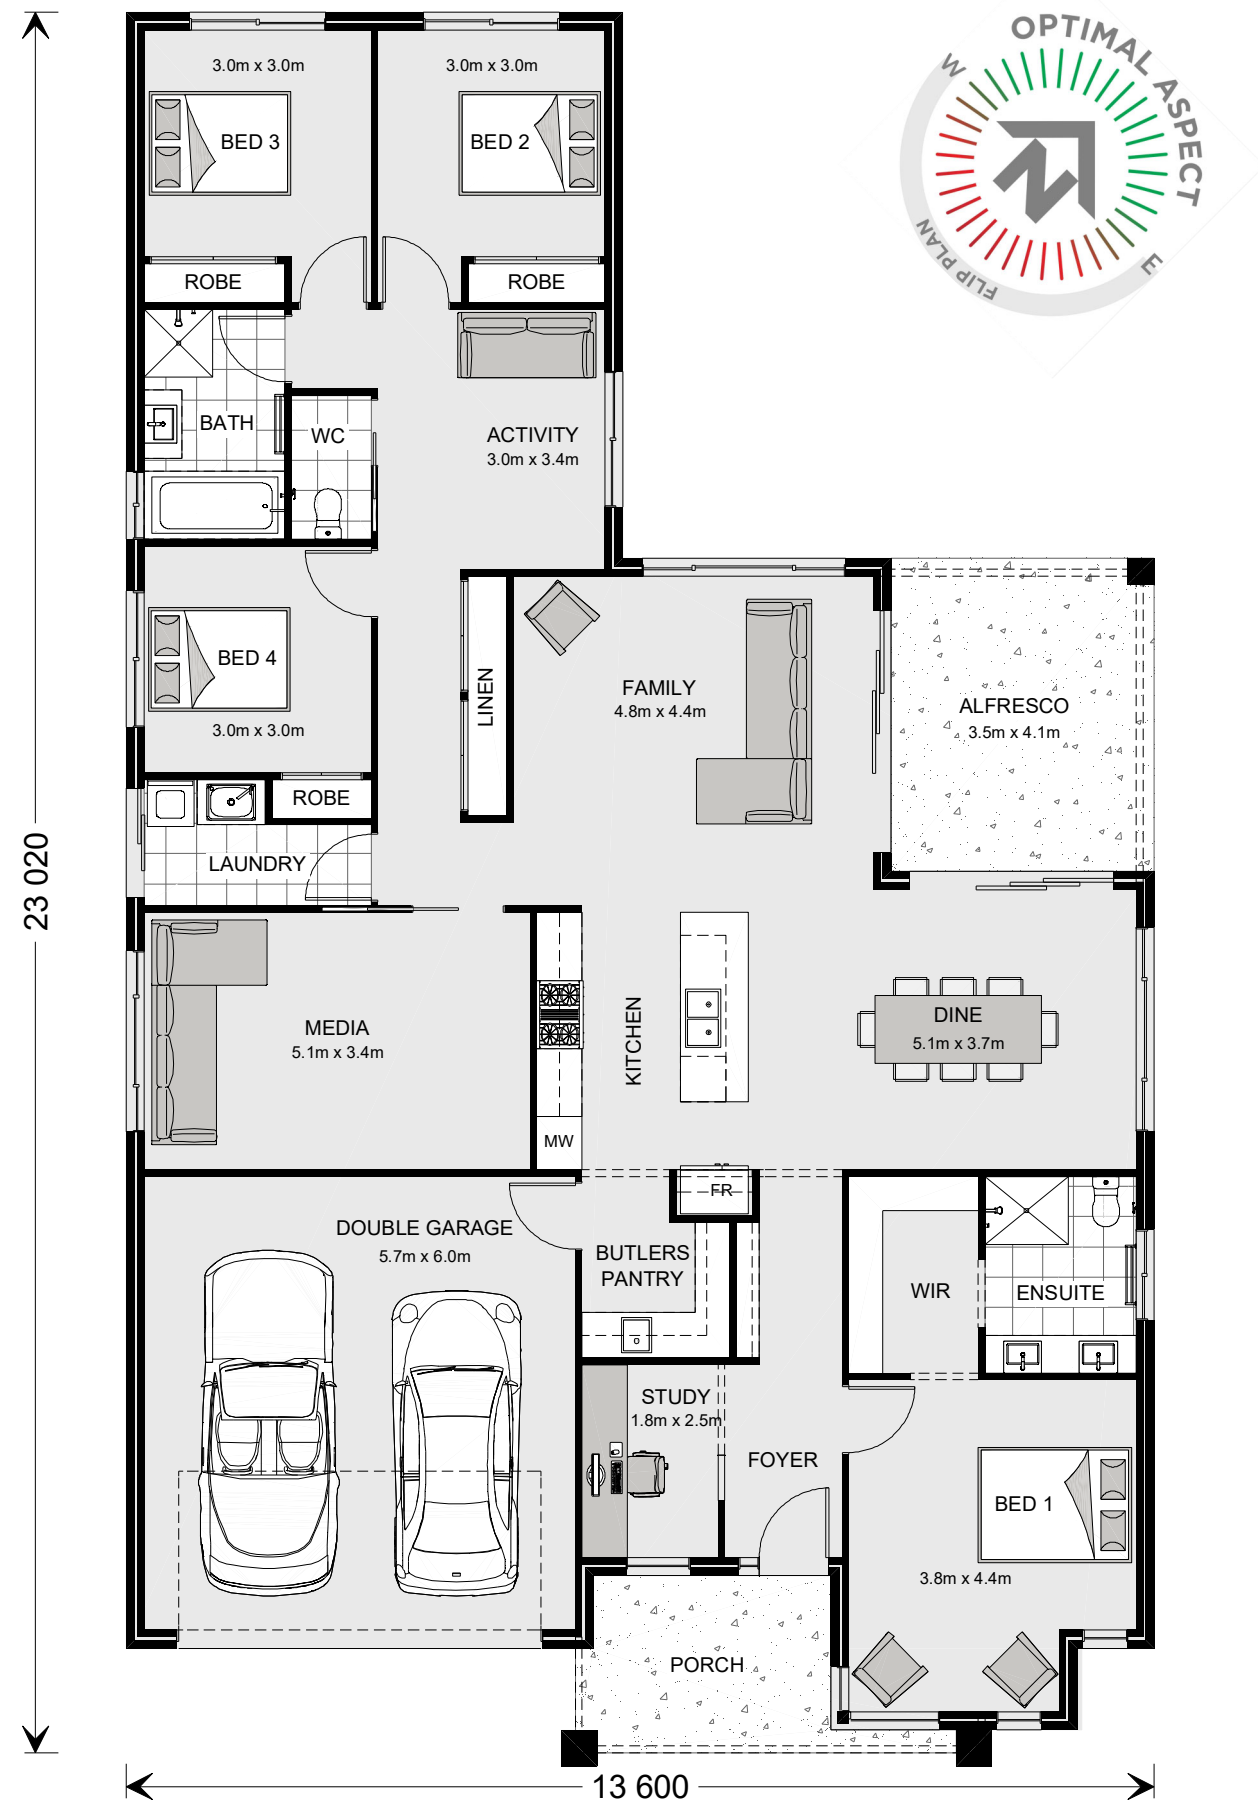


ARTISTS IMPRESSION - for illustrative purposes only
(Coolum 268 Executive Facade)

NCC Compatible


PLANS ARE SUBJECT TO LOCAL COUNCIL & DEVELOPERS GUIDELINES (COVENANTS).

COOLUM 248 Executive Streetscape Element Series	CONCEPT	19/01/2024	FLOOR AREAS	TOTAL	252.7 m ²	Min. Lot Width	PRESENTATION PLAN	G.J. Gardner. HOMES
	© Copyright Archiman Pty Ltd exclusive to G.J. Gardner Homes Concept plans only, final working drawings may vary		LIVING GARAGE ALFRESCO PORCH	192.8 m ² 37.3 m ² 14.4 m ² 8.2 m ²		16 m - 17 m	Scale 1:100 @A3	

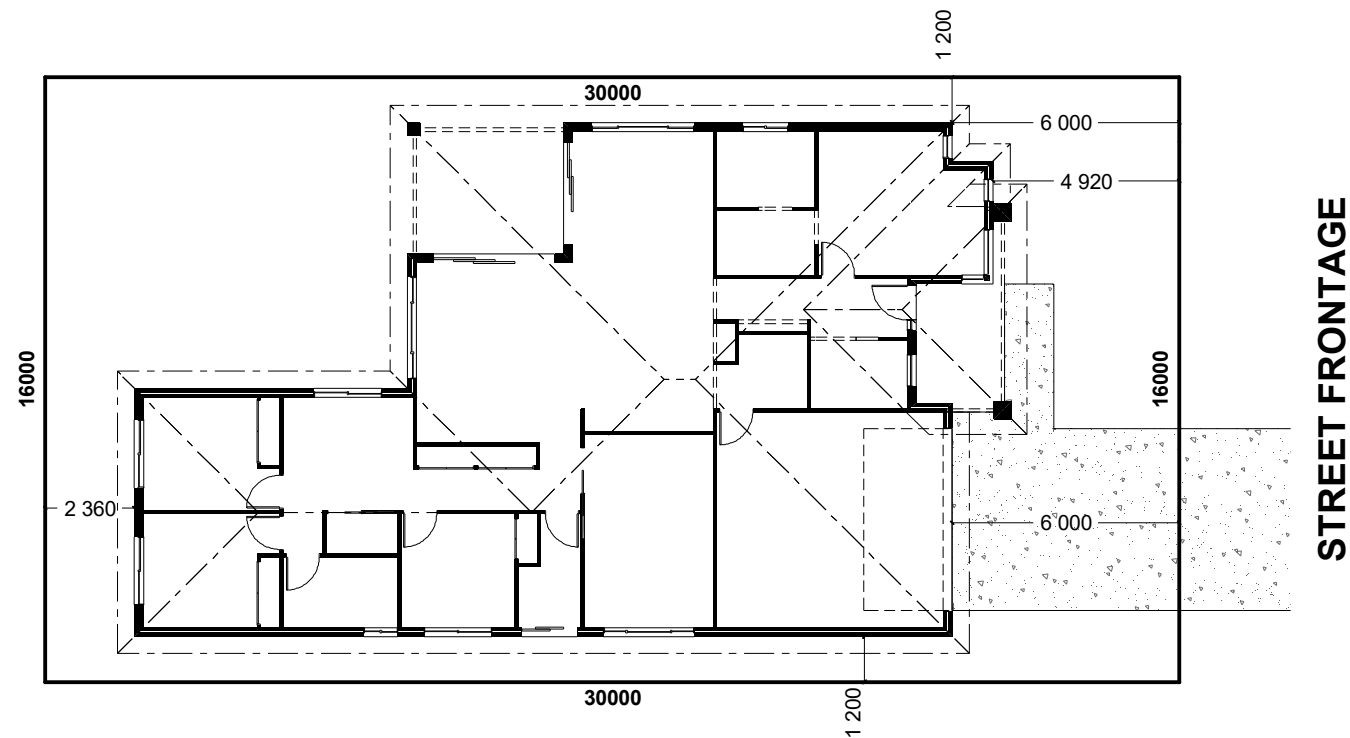

INDICATIVE SITE PLAN ONLY. ACTUAL LOT WIDTH, SIZE AND SETBACKS MAY VARY TO SUIT LOCAL REQUIREMENT'S
AND MAY REQUIRE A LARGER SITE OR PLAN MODIFICATIONS TO SUIT A PARTICULAR SITE.

NCC Compatible					PLANS ARE SUBJECT TO LOCAL COUNCIL & DEVELOPERS GUIDELINES (COVENANTS).			
COOLUM 248 Executive Streetscape	CONCEPT	19/01/2024	FLOOR AREAS	TOTAL	252.7 m²	Min. Lot Width 16 m - 17 m	SITE PLAN Scale 1:200 @A3	G.J. Gardner. HOMES
	© Copyright Archiman Pty Ltd exclusive to G.J. Gardner Homes Concept plans only, final working drawings may vary		LIVING GARAGE ALFRESCO PORCH	192.8 m² 37.3 m² 14.4 m² 8.2 m²				
Element Series								

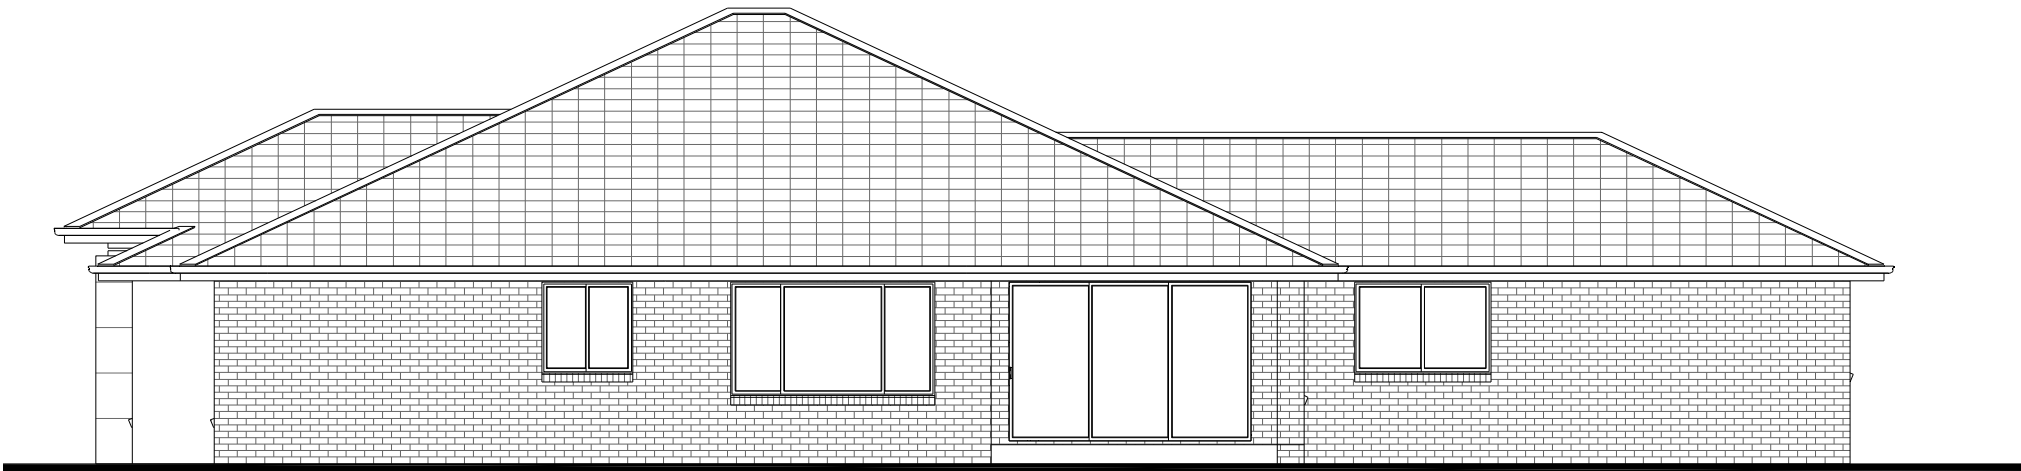

NCC Compatible		PLANS ARE SUBJECT TO LOCAL COUNCIL & DEVELOPERS GUIDELINES (COVENANTS).					
COOLUM 248 Executive Streetscape Element Series		CONCEPT	19/01/2024	FLOOR AREAS	TOTAL 252.7 m ²	Min. Lot Width 16 m - 17 m	ELEVATIONS Scale 1:100 @A3
		© Copyright Archiman Pty Ltd exclusive to G.J. Gardner Homes Concept plans only, final working drawings may vary		LIVING GARAGE ALFRESCO PORCH	192.8 m ² 37.3 m ² 14.4 m ² 8.2 m ²	G.J. Gardner. HOMES	

ELECTRICAL LEGEND

NOTE:
ALL ELECTRICAL WORK MUST
BE COMPLETED TO THE
RELEVANT AUSTRALIAN
STANDARDS AND THE
NATIONAL CONSTRUCTION
CODE OF AUSTRALIA.

LIGHTING *EEF (denotes energy efficient light fittings)


Symbol	Description	Spec.	Extra
	Ceiling Light *EEF	-	-
	Down Light *EEF	-	-
	Wall Light *EEF approx height	-	-
	Pendant / Track Light *EEF	-	-
	IXL Tastic (or similar)	-	-
	Batten Fluro Light *EEF	-	-
	Round Fluro Light *EEF	-	-
	Flood / Spot Light *EEF	-	-
TOTAL LIGHT POINTS		-	-

POWER

	Quad Power Point	-	-
	Single Power Point	-	-
	Double Power Point	-	-
	Double W/Proof Power Point	-	-
	Single W/Proof Power Point	-	-
	T.V. Point	-	-
	Phone Point	-	-
	T.V Antenna & Booster inc. SGPO	-	-
	Dishwasher Point	-	-
	Rangehood Point	-	-
	Microwave Point	-	-
	Oven Point	-	-
	Cook Top Iso point	-	-

MISCELLANEOUS

	Exhaust Fan	-	-
	Ceiling Fan (stainless steel)	-	-
	Ceiling Fan & Light (white) *EEF	-	-
	Meter Box	-	-
	Hot Water Service	-	-
	Smoke Detectors	-	-
	Dimmer Switch	-	-
	Two Way Switch	-	-
	A/C Condensor Iso Point	-	-

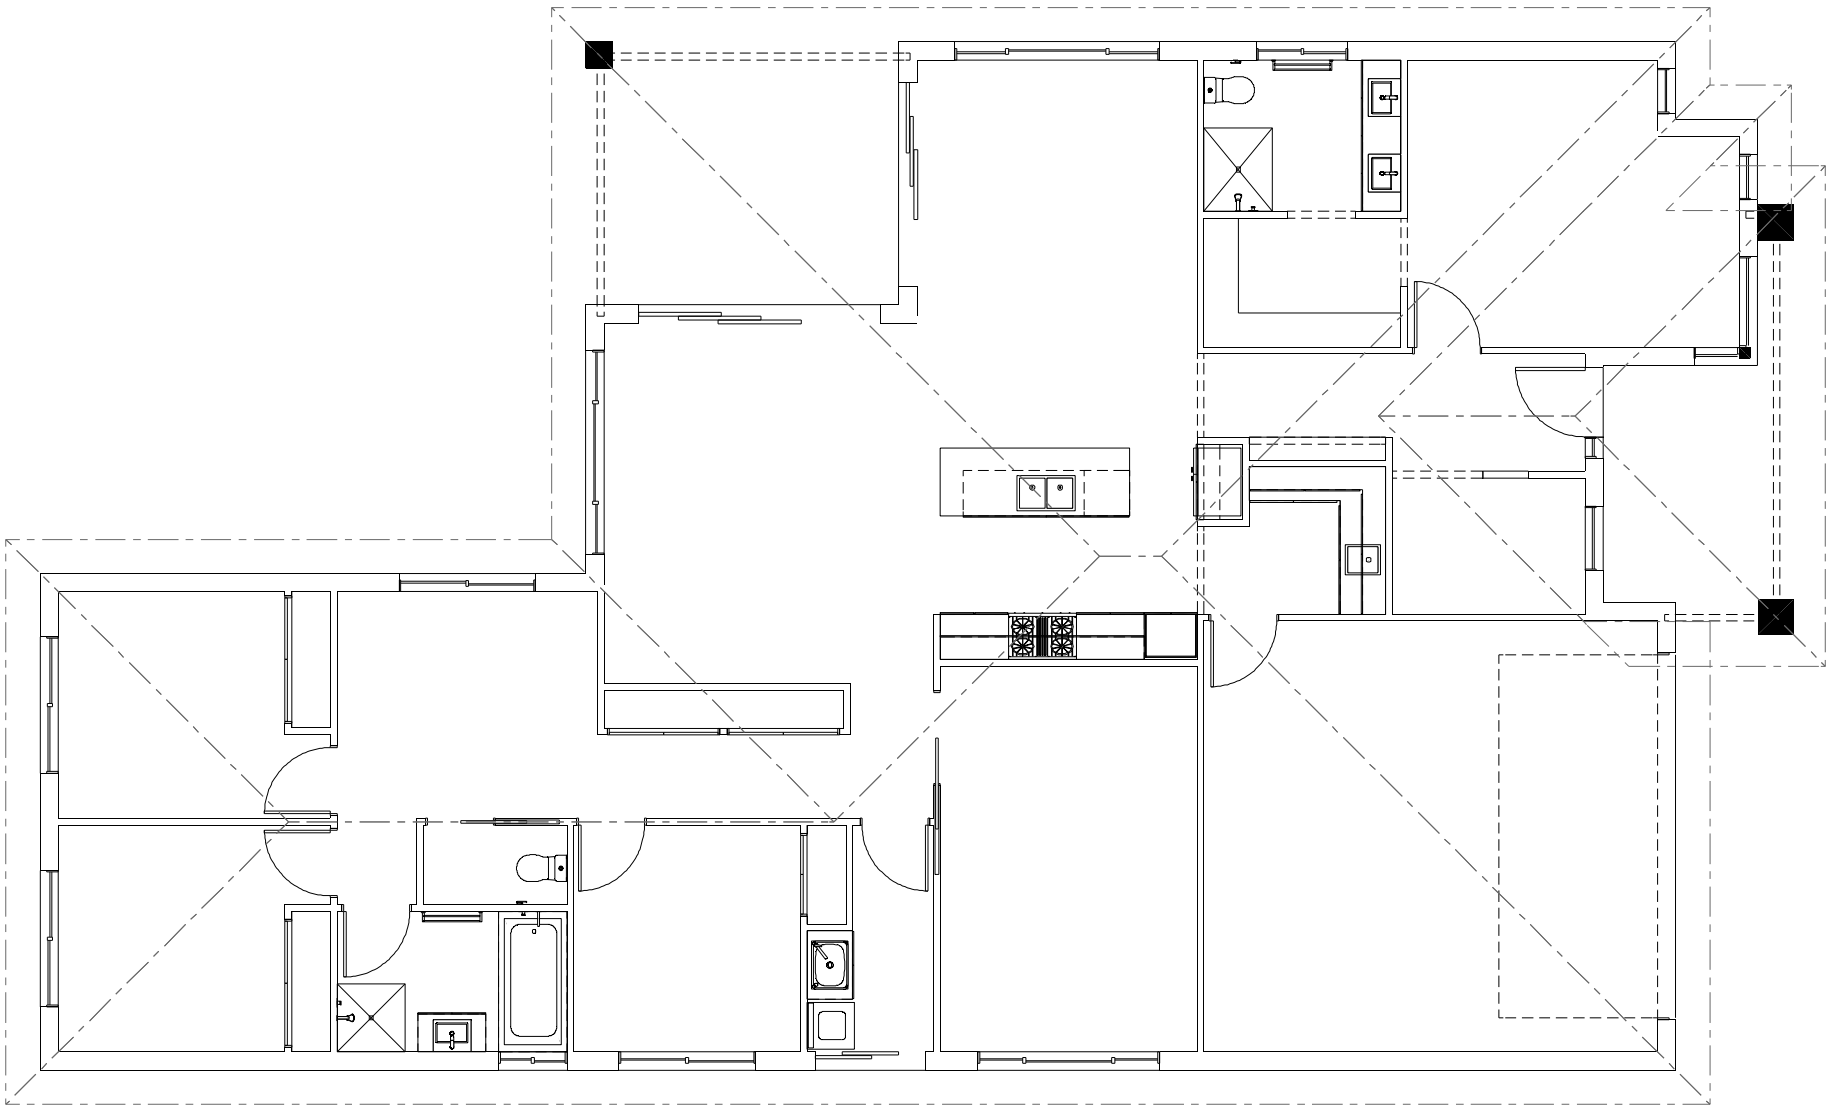

NCC Compatible

COOLUM 248

Executive Streetscape

Element Series

CONCEPT19/01/2024

© Copyright Archiman Pty Ltd
exclusive to
G.J. Gardner Homes
Concept plans only,
final working drawings may vary

FLOOR AREAS

LIVING
GARAGE
ALFRESCO
PORCH

TOTAL252.7 m²

192.8 m²
37.3 m²
14.4 m²
8.2 m²

PLANS ARE SUBJECT TO LOCAL COUNCIL & DEVELOPERS GUIDELINES (COVENANTS).

Min. Lot Width
16 m - 17 m

ELECTRICAL PLAN

Scale 1:100 @A3

G.J. Gardner.

HOMES