




ARTISTS IMPRESSION - for illustrative purposes only
(South Bank 530 Hamptons Facade)

NCC Compatible

PLANS ARE SUBJECT TO LOCAL COUNCIL & DEVELOPERS GUIDELINES (COVENANTS).

SOUTH BANK 385 Hamptons Streetscape	CONCEPT 17/04/2024	TOTAL FLOOR AREA = 377.4 m²		Min. Lot Width 14.5 m - 16 m	ARTIST IMPRESSION N.T.S.	G.J. Gardner. HOMES
	© Copyright Archiman Pty Ltd exclusive to G.J. Gardner Homes Concept plans only, final working drawings may vary	GF LIVING 136.4 m² GARAGE 35.3 m² ALFRESCO 19.4 m² PORCH 7.3 m² GF TOTAL 198.4 m²	UF LIVING 135.1 m² VOID 38.7 m² BALCONY 5.2 m² UF TOTAL 179.0 m²			
Element Series						

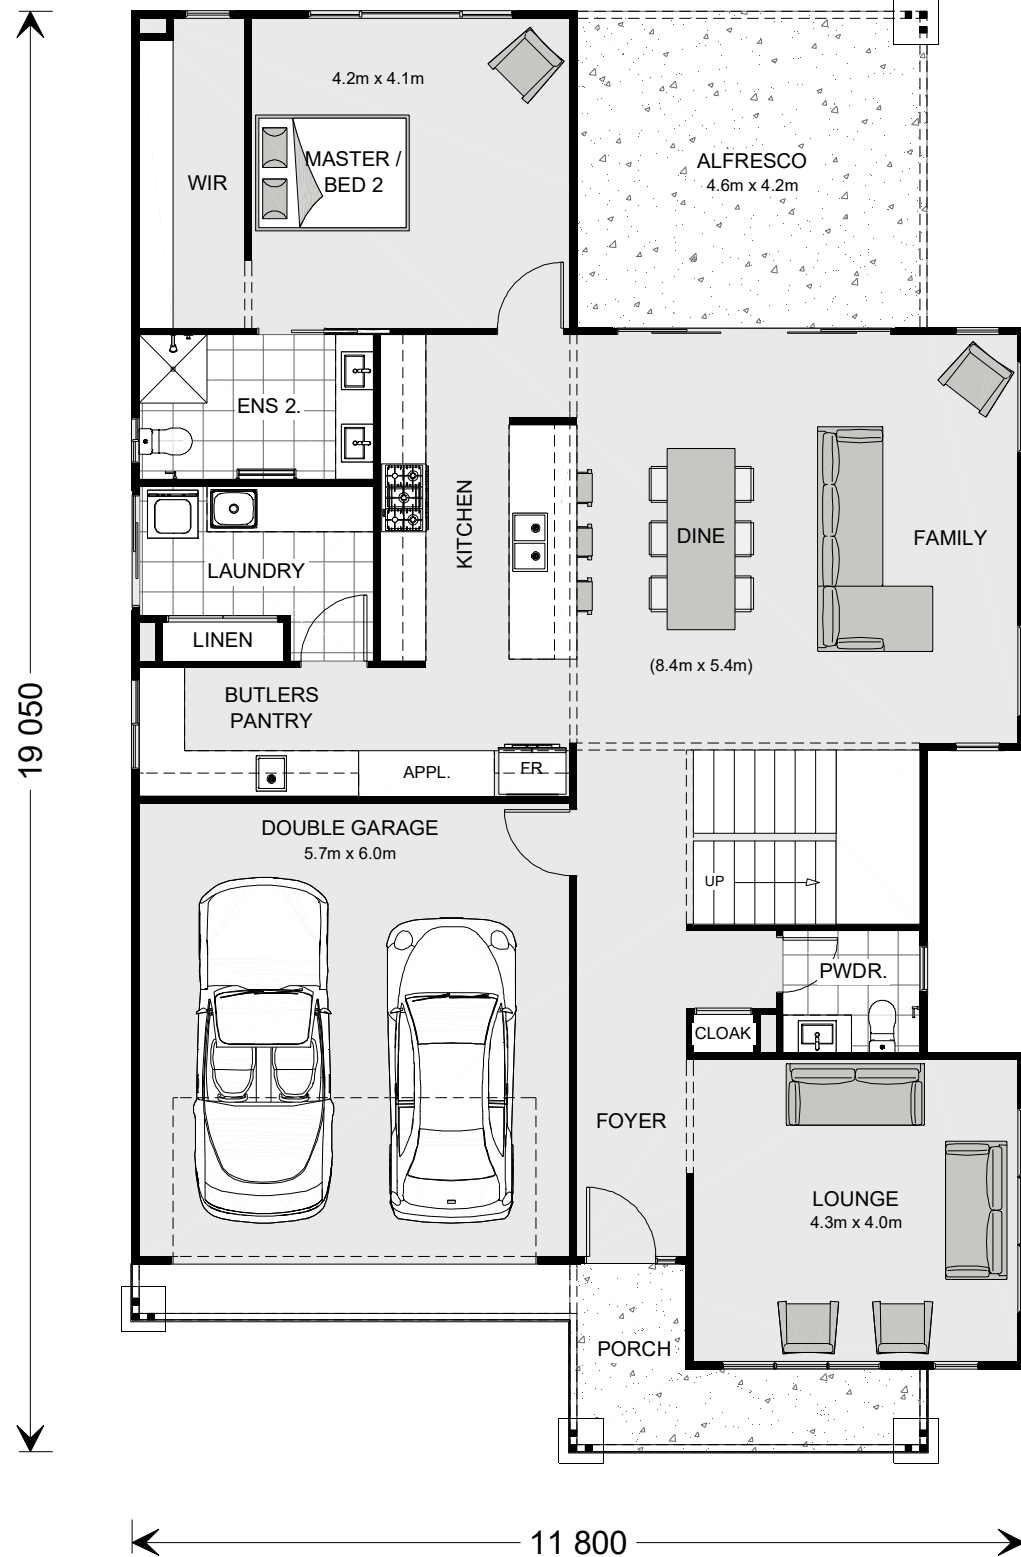

NCC Compatible

PLANS ARE SUBJECT TO LOCAL COUNCIL & DEVELOPERS GUIDELINES (COVENANTS).

SOUTH BANK 385

Hamptons Streetscape

Element Series

CONCEPT 17/04/2024
© Copyright Archiman Pty Ltd
exclusive to
G.J. Gardner Homes
Concept plans only,
final working drawings may vary



TOTAL FLOOR AREA = 377.4 m ²			
GF LIVING	136.4 m ²	UF LIVING	135.1 m ²
GF GARAGE	35.3 m ²	UF VOID	38.7 m ²
GF ALFRESCO	19.4 m ²	UF BALCONY	5.2 m ²
GF PORCH	7.3 m ²		
GF TOTAL	198.4 m ²	UF TOTAL	179.0 m ²

Min. Lot Width
14.5 m - 16 m

PRESENTATION PLAN
Scale 1:100 @A3

G.J. Gardner.

HOMES

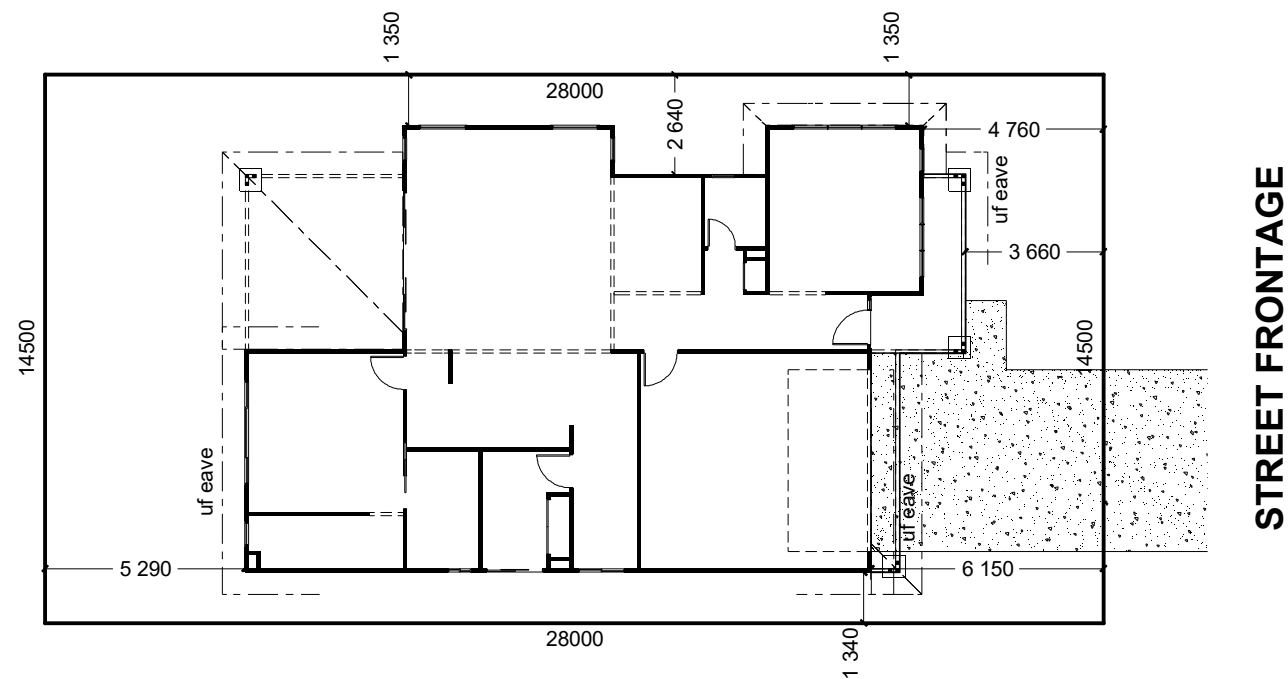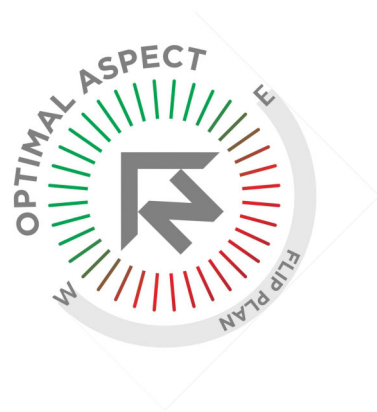

INDICATIVE SITE PLAN ONLY. ACTUAL LOT WIDTH, SIZE AND SETBACKS MAY VARY TO SUIT LOCAL REQUIREMENT'S AND MAY REQUIRE A LARGER SITE OR PLAN MODIFICATIONS TO SUIT A PARTICULAR SITE.

NCC Compatible

PLANS ARE SUBJECT TO LOCAL COUNCIL & DEVELOPERS GUIDELINES (COVENANTS).

SOUTH BANK 385

Hamptons Streetscape

Element Series


CONCEPT 17/04/2024
© Copyright Archiman Pty Ltd
exclusive to
G.J. Gardner Homes
Concept plans only,
final working drawings may vary

TOTAL FLOOR AREA = 377.4 m ²			
GF LIVING	136.4 m ²	UF LIVING	135.1 m ²
GARAGE	35.3 m ²	VOID	38.7 m ²
ALFRESCO	19.4 m ²	BALCONY	5.2 m ²
PORCH	7.3 m ²		
GF TOTAL	198.4 m ²	UF TOTAL	179.0 m ²


Min. Lot Width
14.5 m - 16 m

SITE PLAN
Scale 1:200 @A3


G.J. Gardner.
HOMES

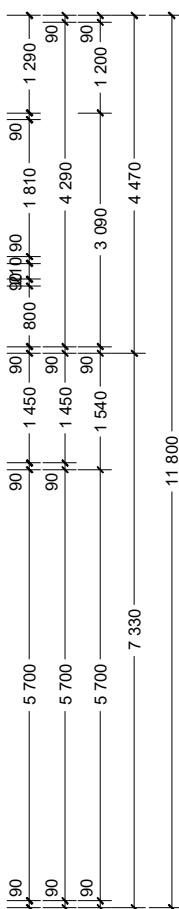

HOMES

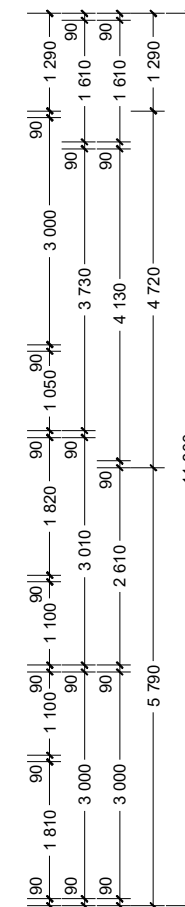

NCC Compatible					PLANS ARE SUBJECT TO LOCAL COUNCIL & DEVELOPERS GUIDELINES (COVENANTS).				
SOUTH BANK 385 Hamptons Streetscape		CONCEPT 17/04/2024	TOTAL FLOOR AREA = 377.4 m²		Min. Lot Width 14.5 m - 16 m	UPPER FLOOR PLAN Scale 1:100 @A3	G.J. Gardner. HOMES		
		© Copyright Archiman Pty Ltd exclusive to G.J. Gardner Homes Concept plans only, final working drawings may vary	GF LIVING 136.4 m² GARAGE 35.3 m² ALFRESCO 19.4 m² PORCH 7.3 m²	UF LIVING 135.1 m² VOID 38.7 m² BALCONY 5.2 m²					
Element Series			GF TOTAL 198.4 m²	UF TOTAL 179.0 m²					

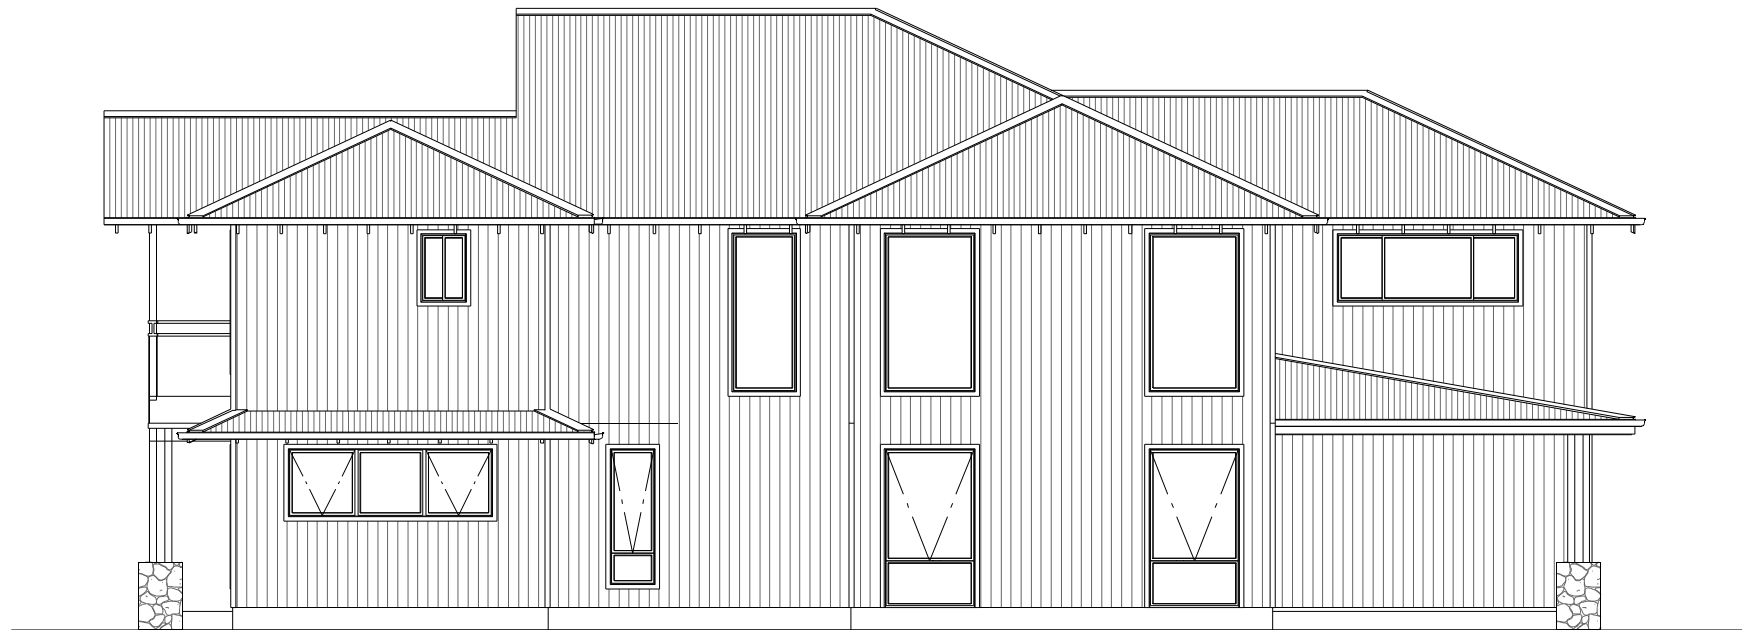

PLANS ARE SUBJECT TO LOCAL COUNCIL & DEVELOPERS GUIDELINES (COVENANTS).

ELEVATIONS

Scale 1:100 @A3

GF TOTAL	198.4 m ²	UF TOTAL	179.0 m ²
----------	----------------------	----------	----------------------

G.J. Gardner.
HOMES

ELECTRICAL LEGEND

NOTE:
ALL ELECTRICAL WORK MUST
BE COMPLETED TO THE
RELEVANT AUSTRALIAN
STANDARDS AND THE
NATIONAL CONSTRUCTION
CODE OF AUSTRALIA.

LIGHTING *EEF (denotes energy efficient light fittings)



Symbol	Description	Spec.	Extra
	Ceiling Light *EEF	-	-
	Down Light *EEF	-	-
	Wall Light *EEF approx height	-	-
	Pendant / Track Light *EEF	-	-
	IXL Tastic (or similar)	-	-
	Batten Fluro Light *EEF	-	-
	Round Fluro Light *EEF	-	-
	Flood / Spot Light *EEF	-	-
TOTAL LIGHT POINTS		-	-

POWER

	Quad Power Point	-	-
	Single Power Point	-	-
	Double Power Point	-	-
	Double W/Proof Power Point	-	-
	Single W/Proof Power Point	-	-
	T.V. Point	-	-
	Phone Point	-	-
	T.V Antenna & Booster inc. SGPO	-	-
	Dishwasher Point	-	-
	Rangehood Point	-	-
	Microwave Point	-	-
	Oven Point	-	-
	Cook Top Iso point	-	-

MISCELLANEOUS

	Exhaust Fan	-	-
	Ceiling Fan (stainless steel)	-	-
	Ceiling Fan & Light (white) *EEF	-	-
	Meter Box	-	-
	Hot Water Service	-	-
	Smoke Detectors	-	-
	Dimmer Switch	-	-
	Two Way Switch	-	-
	A/C Condensor Iso Point	-	-

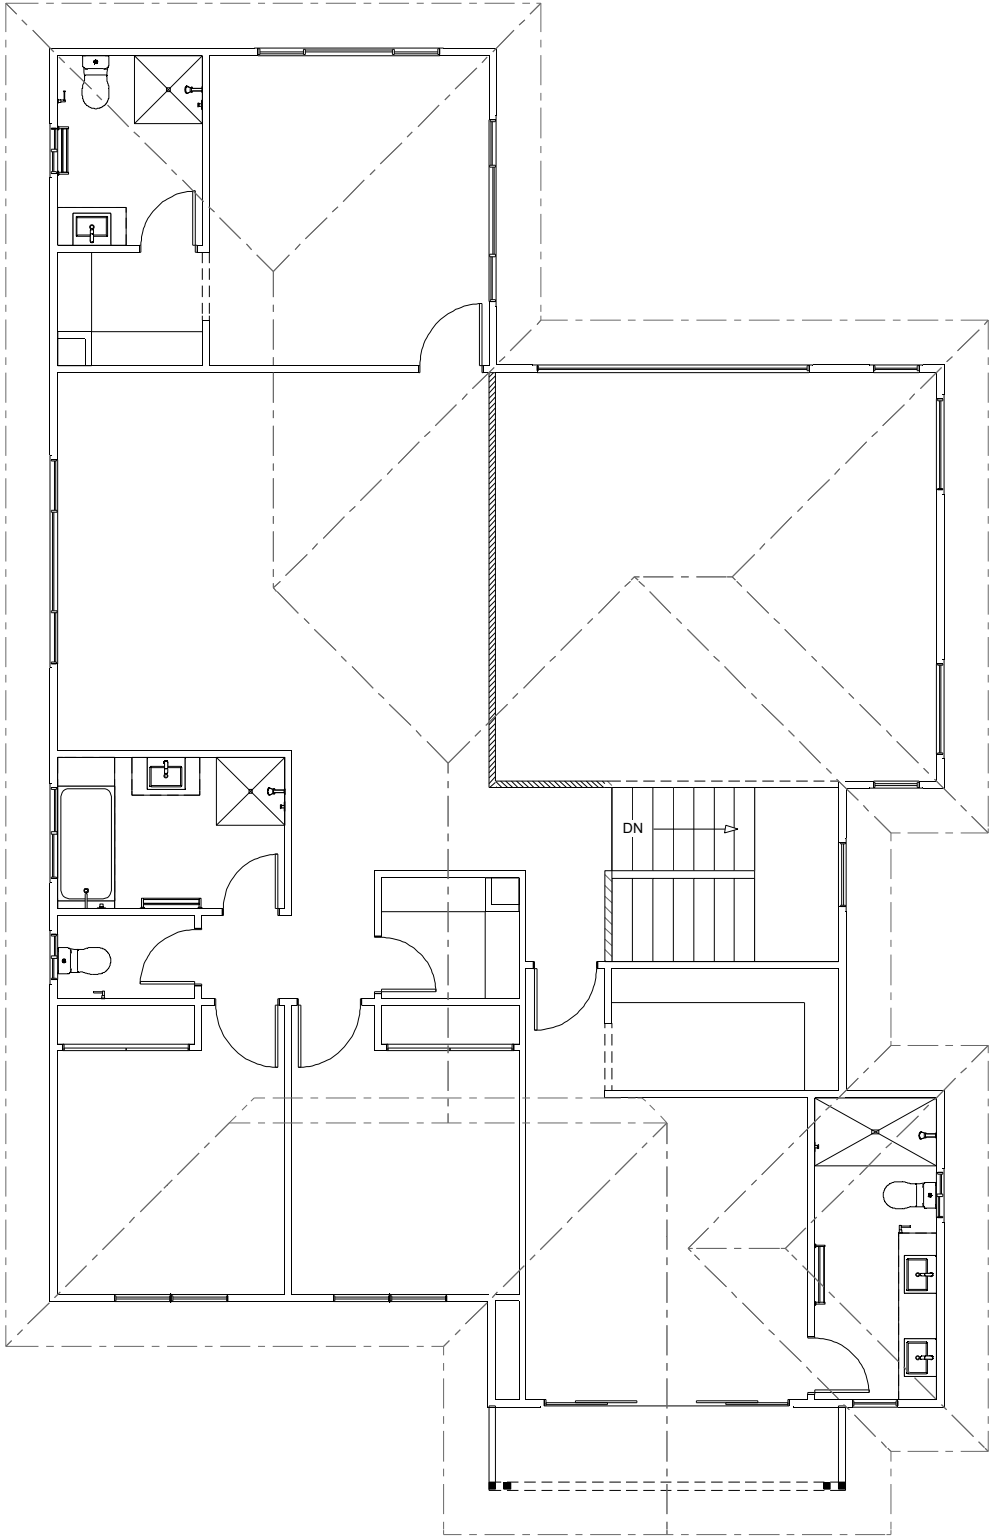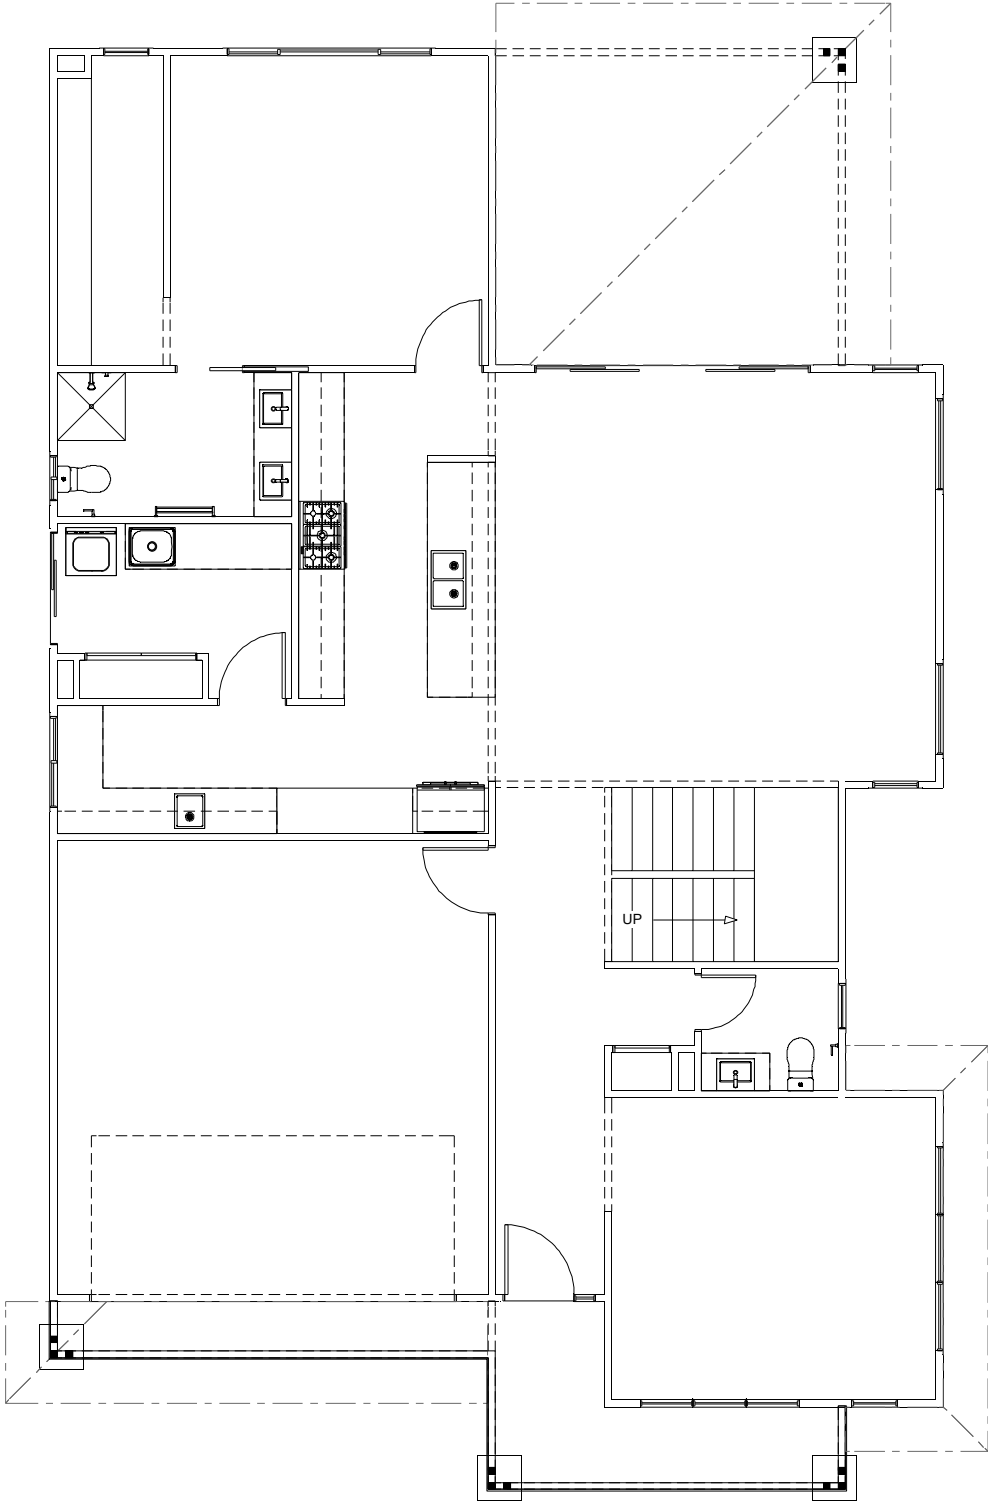

NCC Compatible

PLANS ARE SUBJECT TO LOCAL COUNCIL & DEVELOPERS GUIDELINES (COVENANTS).

SOUTH BANK 385 Hamptons Streetscape Element Series	CONCEPT	17/04/2024	TOTAL FLOOR AREA = 377.4 m²		Min. Lot Width	14.5 m - 16 m	ELECTRICAL PLAN	Scale 1:100 @A3	G.J. Gardner. HOMES			
	© Copyright Archiman Pty Ltd exclusive to G.J. Gardner Homes Concept plans only, final working drawings may vary		GF LIVING	136.4 m²	UF LIVING	135.1 m²						
			GARAGE	35.3 m²	VOID	38.7 m²						
			ALFRESCO	19.4 m²	BALCONY	5.2 m²						
			PORCH	7.3 m²								
			GF TOTAL	198.4 m²	UF TOTAL	179.0 m²						