


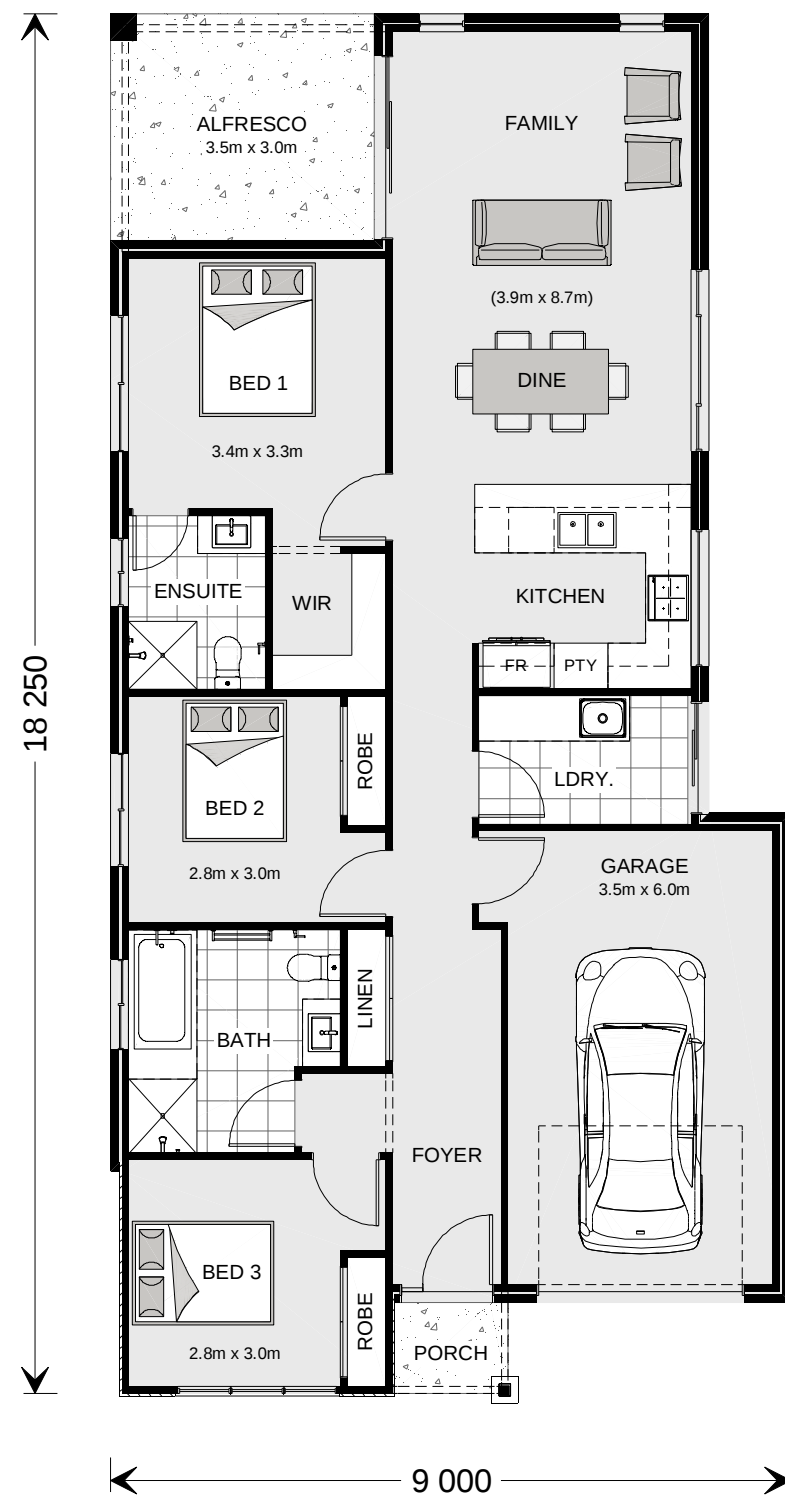

ARTISTS IMPRESSION - for illustrative purposes only

NCC Compatible

PLANS ARE SUBJECT TO LOCAL COUNCIL & DEVELOPERS GUIDELINES (COVENANTS).

ARMADALE 149

Hamptons Streetscape

Metro Series

CONCEPT 17/06/2024

© Copyright Archiman Pty Ltd
exclusive to
G.J. Gardner Homes
Concept plans only,
final working drawings may vary

FLOOR AREAS

TOTAL 147.9 m²


LIVING	111.5 m ²
GARAGE	24.1 m ²
ALFRESCO	10.5 m ²
PORCH	1.8 m ²

Min. Lot Width
10 m - 12 m

PRESENTATION PLAN
Scale 1:100 @A3

G.J. Gardner.

HOMES

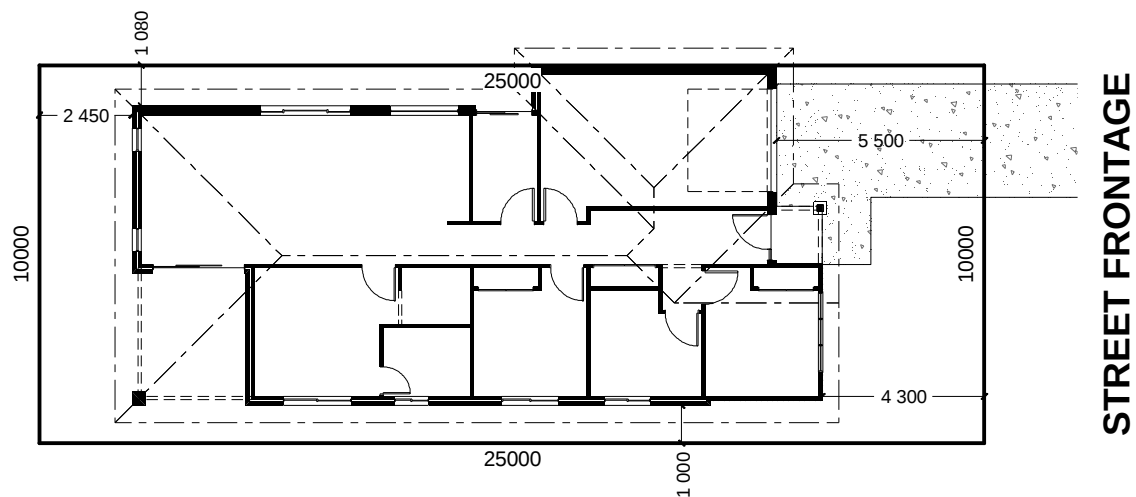


INDICATIVE SITE PLAN ONLY. ACTUAL LOT WIDTH, SIZE AND SETBACKS MAY VARY TO SUIT LOCAL REQUIREMENT'S AND MAY REQUIRE A LARGER SITE OR PLAN MODIFICATIONS TO SUIT A PARTICULAR SITE.



NCC Compatible

PLANS ARE SUBJECT TO LOCAL COUNCIL & DEVELOPERS GUIDELINES (COVENANTS).

ARMADALE 149 Hamptons Streetscape Metro Series	CONCEPT17/06/2024	FLOOR AREAS	TOTAL147.9 m ²	Min. Lot Width 10 m - 12 m	SITE PLAN Scale 1:200 @A3	G.J. Gardner. HOMES
	© Copyright Archiman Pty Ltd exclusive to G.J. Gardner Homes Concept plans only, final working drawings may vary	LIVING GARAGE ALFRESCO PORCH	111.5 m ² 24.1 m ² 10.5 m ² 1.8 m ²			

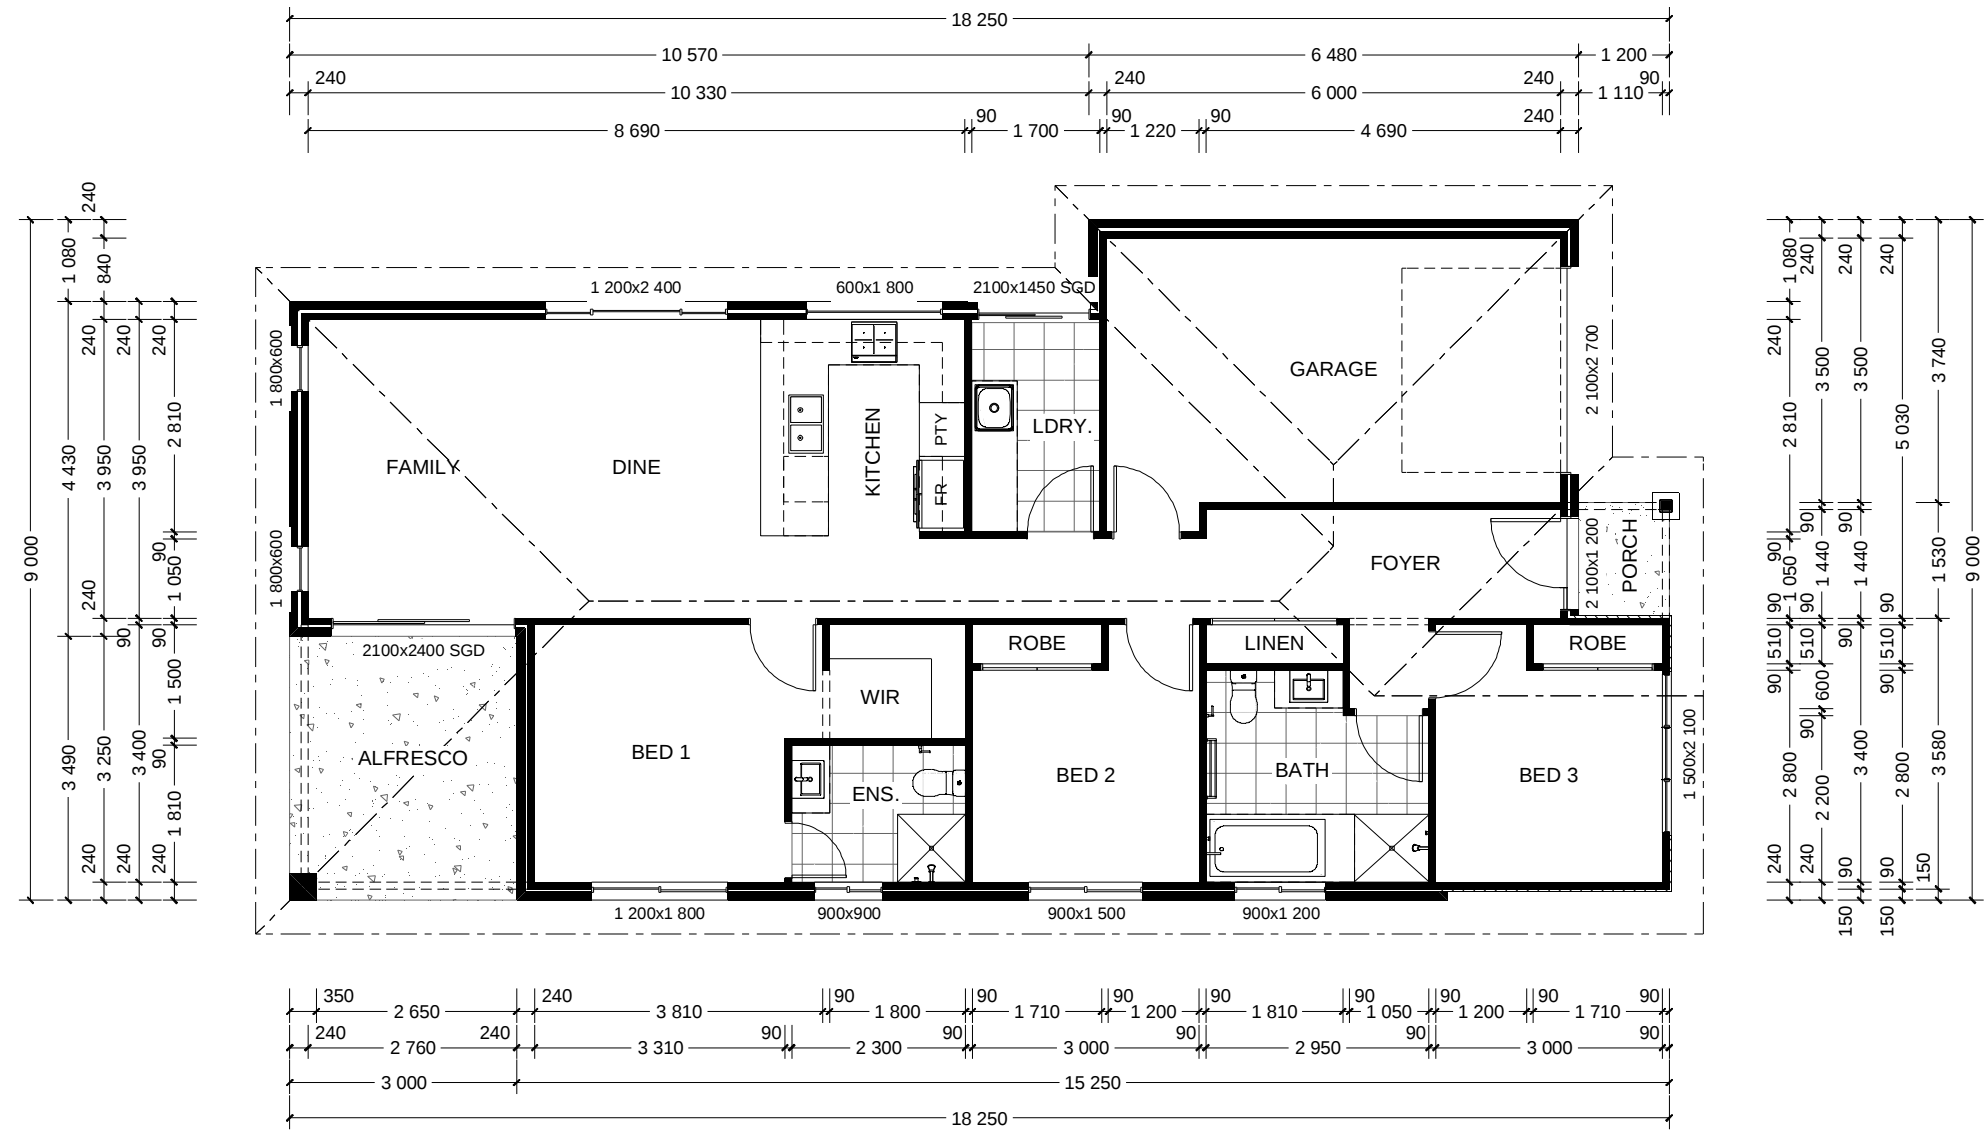

NCC Compatible		PLANS ARE SUBJECT TO LOCAL COUNCIL & DEVELOPERS GUIDELINES (COVENANTS).				
ARMADALE 149 Hamptons Streetscape Metro Series	CONCEPT 17/06/2024	FLOOR AREAS	TOTAL 147.9 m²	Min. Lot Width 10 m - 12 m	FLOOR PLAN Scale 1:100 @A3	G.J. Gardner. HOMES
	© Copyright Archiman Pty Ltd exclusive to G.J. Gardner Homes Concept plans only, final working drawings may vary	LIVING GARAGE ALFRESCO PORCH	111.5 m² 24.1 m² 10.5 m² 1.8 m²			

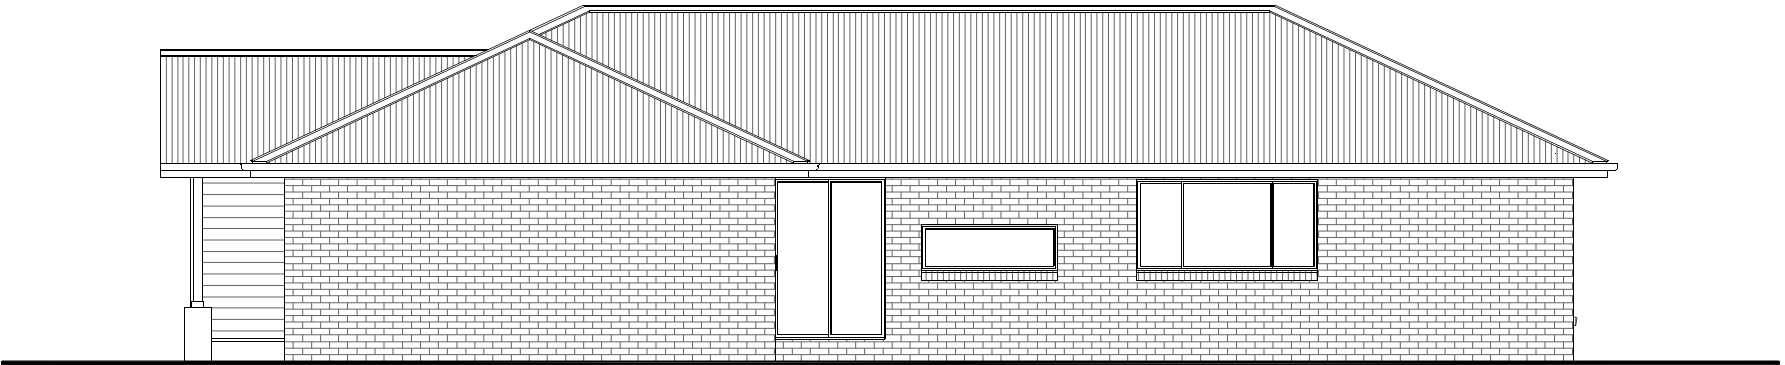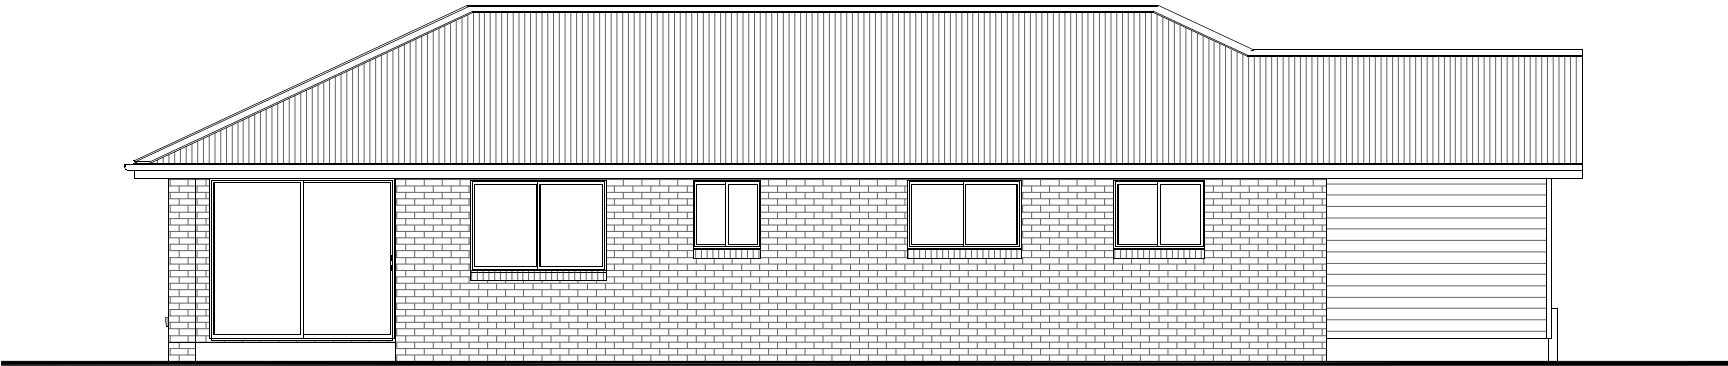

NCC Compatible

PLANS ARE SUBJECT TO LOCAL COUNCIL & DEVELOPERS GUIDELINES (COVENANTS).

ARMADALE 149

Hamptons Streetscape

Metro Series

CONCEPT 17/06/2024

© Copyright Archiman Pty Ltd
exclusive to
G.J. Gardner Homes
Concept plans only,
final working drawings may vary

FLOOR AREAS TOTAL 147.9 m²

LIVING	111.5 m ²
GARAGE	24.1 m ²
ALFRESCO	10.5 m ²
PORCH	1.8 m ²

Min. Lot Width
10 m - 12 m

ELEVATIONS
Scale 1:100 @A3

G.J. Gardner.

HOMES

ELECTRICAL LEGEND

NOTE:
ALL ELECTRICAL WORK MUST
BE COMPLETED TO THE
RELEVANT AUSTRALIAN
STANDARDS AND THE
NATIONAL CONSTRUCTION
CODE OF AUSTRALIA.

LIGHTING *EEF (denotes energy efficient light fittings)


Symbol	Description	Spec.	Extra
	Ceiling Light *EEF	-	-
	Down Light *EEF	-	-
	Wall Light *EEF approx height	-	-
	Pendant / Track Light *EEF	-	-
	IXL Tastic (or similar)	-	-
	Batten Fluro Light *EEF	-	-
	Round Fluro Light *EEF	-	-
	Flood / Spot Light *EEF	-	-
TOTAL LIGHT POINTS		-	-

POWER

	Quad Power Point	-	-
	Single Power Point	-	-
	Double Power Point	-	-
	Double W/Proof Power Point	-	-
	Single W/Proof Power Point	-	-
	T.V. Point	-	-
	Phone Point	-	-
	T.V Antenna & Booster inc. SGPO	-	-
	Dishwasher Point	-	-
	Rangehood Point	-	-
	Microwave Point	-	-
	Oven Point	-	-
	Cook Top Iso point	-	-

MISCELLANEOUS

	Exhaust Fan	-	-
	Ceiling Fan (stainless steel)	-	-
	Ceiling Fan & Light (white) *EEF	-	-
	Meter Box	-	-
	Hot Water Service	-	-
	Smoke Detectors	-	-
	Dimmer Switch	-	-
	Two Way Switch	-	-
	A/C Condensor Iso Point	-	-

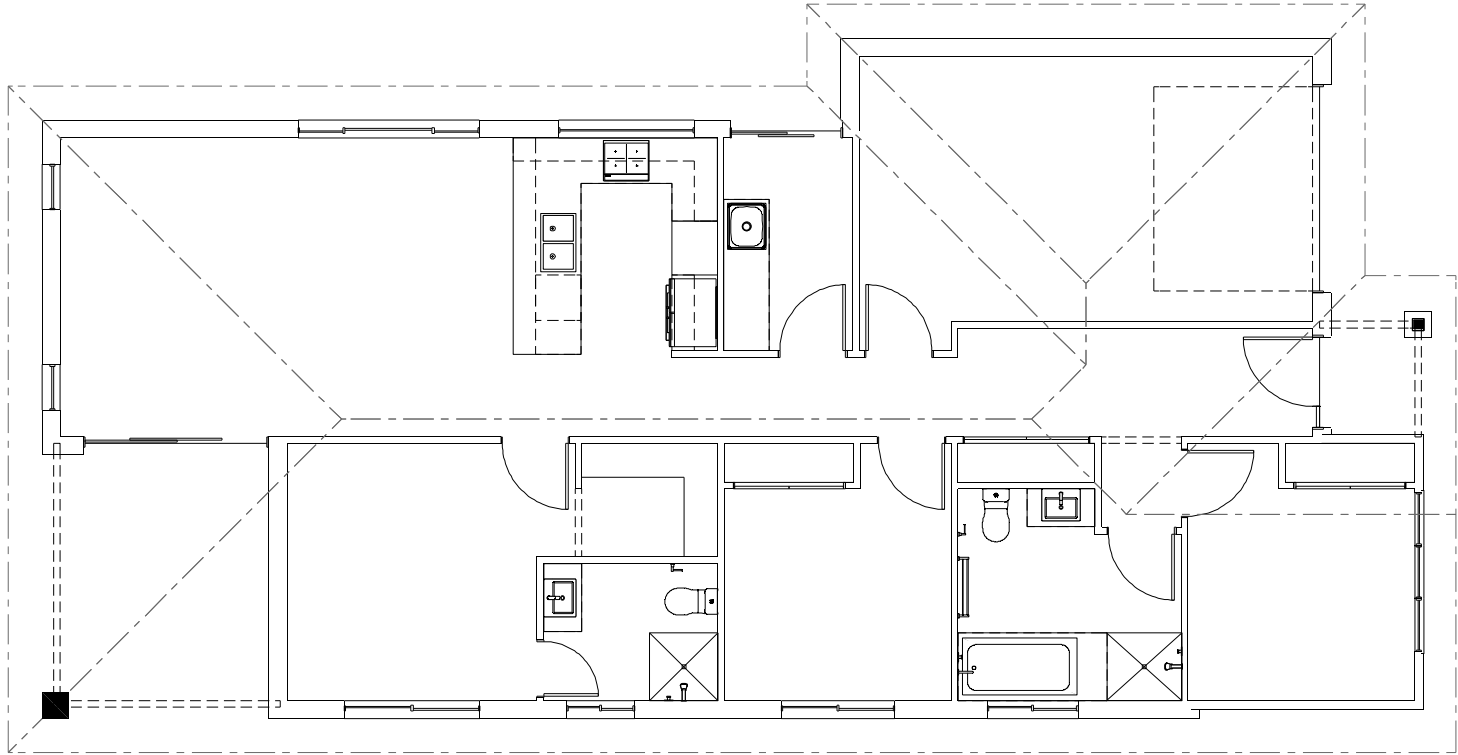

NCC Compatible

PLANS ARE SUBJECT TO LOCAL COUNCIL & DEVELOPERS GUIDELINES (COVENANTS).

ARMADALE 149

Hamptons Streetscape

Metro Series

CONCEPT17/06/2024

© Copyright Archiman Pty Ltd
exclusive to
G.J. Gardner Homes
Concept plans only,
final working drawings may vary

FLOOR AREAS	TOTAL147.9 m²
LIVING	111.5 m²
GARAGE	24.1 m²
ALFRESCO	10.5 m²
PORCH	1.8 m²

Min. Lot Width
10 m - 12 m

ELECTRICAL PLAN
Scale 1:100 @A3

G.J. Gardner.

HOMES